


City Of Helena Amphitheater Electrical Layout

May 2008 Drawn by Randall Perrin

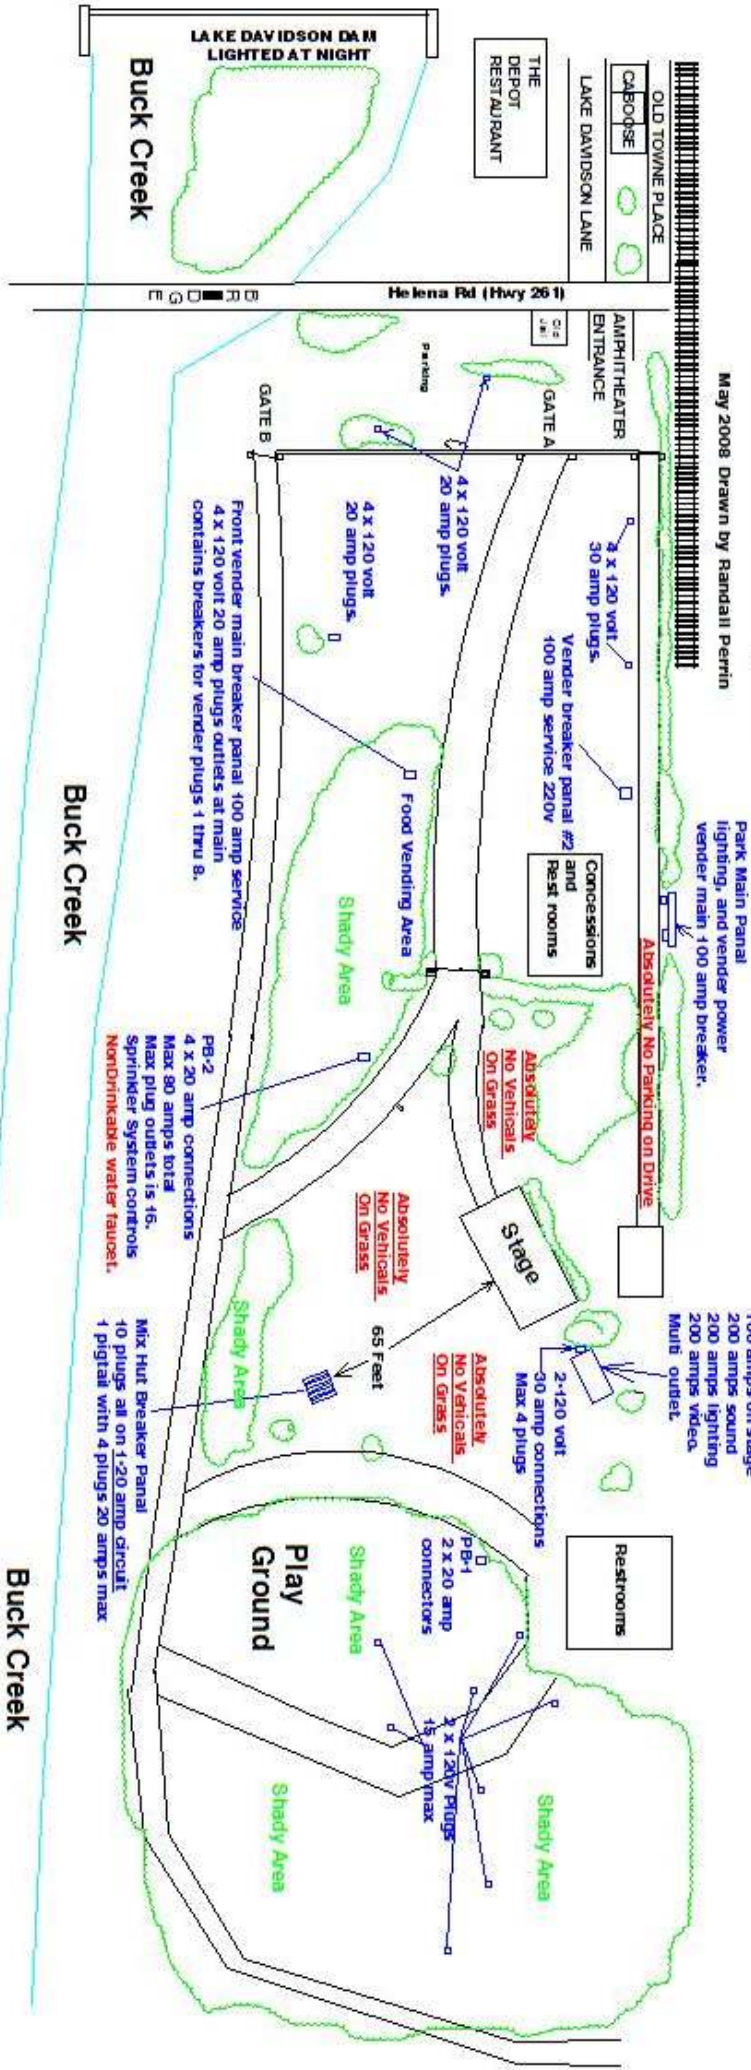

Park Main Panel
lighting, and vendor power
Vendor main 100 amp breaker.

Absolutely No Parking on Drive

Stage Main Power
100 amps on stage
200 amps sound
200 amps lighting
200 amps video.
Multi outlet.

Concessions
Vendor breaker panel #2 and
Rest rooms

Stage

Restrooms

AMPHITHEATER
ENTRANCE
GATE A
GATE B
4 x 120 volt
20 amp plugs.
4 x 120 volt
20 amp plugs.
Front vendor main breaker panel 100 amp service
4 x 120 volt 20 amp plugs outlets at main
contains breakers for vendor plugs 1 thru 8.

2-120 volt
30 amp connections
Max 4 plugs
PB-1
2 x 20 amp
connectors
1 x 120V Plugs
15 amp max
Shady Area
Shady Area
Shady Area

PB-2
4 x 20 amp connections
Max 80 amps total
Max plug outlets is 16.
Sprinkler System controls
Non-Drinkable water faucet.

Mix Hut Breaker Panel
10 plugs all on 120 amp circuit
1 pigtail with 4 plugs 20 amps max

OLD TOWNE PLACE
CABOOSE
LAKE DAVIDSON LANE
THE
DEPOT
RESTAURANT

LAKE DAVIDSON DAM
LIGHTED AT NIGHT

Buck Creek

Buck Creek

Buck Creek

Helena Pbl (Hwy 26)