

LATHAN
ARCHITECTS

DRAWING INDEX (SET - 133 TOTAL SHEETS)

T1	- TITLE AND INDEX
LS1.1	- FIRST FLOOR LIFE SAFETY PLAN
LS1.2	- SECOND FLOOR LIFE SAFETY PLAN
LS1.3	- THREE FLOOR LIFE SAFETY PLAN

C0.1	- GENERAL CIVIL NOTES
C0.2	- OVERALL EXISTING CONDITIONS PLAN
C1.0	- SITE DEMOLITION PLAN
C2.0	- SITE LAY-OUT PLAN
C3.0	- GRADING & DRAINAGE PLAN
C3.1	- STORM PROFILES
C4.0	- SITE UTILITY PLAN
C5.0	- EROSION CONTROL PLAN (PHASE 1)
C5.1	- EROSION CONTROL PLAN (PHASE 2)
C5.2	- EROSION CONTROL PLAN (PHASE 3)
C6.0	- CIVIL DETAILS
C6.1	- CIVIL DETAILS

L1.0	- STRUCTURAL SOIL LAYOUT PLAN, BRICK PAVER PLAZA LAYOUT PLAN AND CONSTRUCTION DETAILS
L2.0	- PLANTING PLAN
L2.1	- PLANTING DETAILS
L3.0	- IRRIGATION PLAN
L3.1	- IRRIGATION SLEEVING PLAN
L3.2	- IRRIGATION DETAILS

- A2.1 - FIRST FLOOR PLAN
- A2.2 - SECOND FLOOR PLAN
- A2.3 - THIRD FLOOR PLAN
- A2.4 - ROOF PLAN
- A2.5 - ROOF DETAILS
- A2.6 - DOOR AND WINDOW SCHEDULE
- A2.6.1 - DOOR AND WINDOW DETAILS
- A2.7 - ENLARGED PLANS
- A2.8 - ENLARGED PLANS - EQUIPMENT YARDS
- A2.9 - PRECAST COLUMN ELEVATIONS, PRECAST PLAN
DETAILS AND PROFILES
- A3.1 - BUILDING ELEVATIONS
- A3.2 - BUILDING ELEVATIONS
- A3.2.1 - ENLARGED ELEVATIONS
- A3.3 - BUILDING SECTIONS
- A3.4 - BUILDING SECTIONS
- A3.5 - WALL SECTIONS
- A3.6 - WALL SECTIONS
- A3.7 - WALL SECTIONS
- A3.8 - SECTION DETAILS
- A4.1 - STAIR 1 - ENLARGED PLANS, SECTIONS AND DETAILS
- A4.2 - STAIR 2&3 - ENLARGED PLANS, SECTIONS AND DETAILS
- A4.3 - STAIR 4 - ENLARGED PLANS, SECTIONS AND DETAILS
- A4.4 - STAIR 5 - ENLARGED PLANS, SECTIONS AND DETAILS
- A4.5 - ENLARGED ELEVATOR PLANS, SECTIONS AND DETAILS
- A4.6 - TYPICAL STAIR DETAILS
- A5.1 - ENLARGED TOILET PLANS AND DETAILS
- A5.2 - TOILET ELEVATIONS
- A6.1 - FIRST FLOOR CASEWORK PLAN
- A6.2 - SECOND FLOOR CASEWORK PLAN
- A6.3 - INTERIOR ELEVATIONS
- A6.4 - INTERIOR ELEVATIONS
- A6.5 - CASEWORK ELEVATIONS
- A6.6 - CASEWORK ELEVATIONS
- A6.7 - INTERIOR ELEVATIONS
- A7.1 - FIRST FLOOR REFLECTED CEILING PLAN
- A7.2 - SECOND FLOOR REFLECTED CEILING PLAN
- A7.3 - THIRD FLOOR REFLECTED CEILING PLAN
- A7.4 - CEILING LEGEND AND DETAILS
- A8.1 - FIRST FLOOR FINISH PLAN
- A8.2 - SECOND FLOOR FINISH PLAN
- A8.3 - THIRD FLOOR FINISH PLAN
- A8.4 - LVT AND CARPET PATTERN PLANS AND ENLARGED LOGO
DETAILS
- A8.5 - FINISH SCHEDULE, LEGEND AND DETAILS
- A9.1 - FIRST FLOOR SIGNAGE PLAN
- A9.2 - SECOND FLOOR SIGNAGE PLAN
- A9.3 - THIRD FLOOR SIGNAGE PLAN


- S1.0 - GENERAL NOTES
- S1.1 - GENERAL NOTES CONTINUED
- S1.2 - TYPICAL DETAILS
- S1.3 - TYPICAL DETAILS
- S1.4 - TYPICAL DETAILS
- S1.5 - TYPICAL DETAILS
- S1.6 - TYPICAL DETAILS
- S2.1 - FOUNDATION PLAN
- S2.2 - SECOND FLOOR FRAMING PLAN
- S2.3 - THIRD FLOOR FRAMING PLAN
- S2.4 - ROOF FRAMING PLAN
- S3.1 - SECTIONS AND DETAILS
- S3.2 - SECTIONS AND DETAILS
- S3.3 - SECTIONS AND DETAILS
- S3.4 - SECTIONS AND DETAILS

FP0.01	- FIRE PROTECTION - SCHEDULES, LEGENDS, NOTES & DETAILS
FP0.02	- FIRE PROTECTION - DETAILS
FP1.01	- FIRE PROTECTION - 1ST FLOOR PLAN
FP1.02	- FIRE PROTECTION - 2ND FLOOR PLAN
FP1.03	- FIRE PROTECTION - 3RD FLOOR PLAN


- P0.01 - PLUMBING - SCHEDULES, LEGENDS, NOTES, & DETAILS
- P0.02 - PLUMBING - DETAILS
- P0.03 - PLUMBING - SANITARY RISERS
- P1.01 - NON-PRESSURE - 1ST FLOOR PLAN
- P1.02 - NON-PRESSURE - 2ND FLOOR PLAN
- P1.03 - NON-PRESSURE - 3RD FLOOR PLAN
- P1.04 - PLUMBING - ROOF PLAN
- P2.01 - PRESSURE - 1ST FLOOR PLAN
- P2.02 - PRESSURE - 2ND FLOOR PLAN
- P2.03 - PRESSURE - 3RD FLOOR PLAN
- P3.01 - PLUMBING - ENLARGED PLANS
- P3.02 - PLUMBING - ENLARGED PLANS

M0.01	- MECHANICAL - LEGENDS & NOTES
M0.02	- MECHANICAL - SCHEDULES
M0.03	- MECHANICAL - OSA CALCULATIONS
M0.04	- MECHANICAL - CONTROLS & DETAILS
M0.05	- MECHANICAL - CONTROLS DETAILS
M1.01	- MECHANICAL - 1ST FLOOR PLAN
M1.02	- MECHANICAL - 2ND FLOOR PLAN
M1.03	- MECHANICAL - 3RD FLOOR PLAN
M2.01	- MECHANICAL PIPING - 1ST FLOOR PLAN
M2.02	- MECHANICAL PIPING - 2ND FLOOR PLAN
M2.03	- MECHANICAL PIPING - 3RD FLOOR PLAN

- E0.1 - ELECTRICAL SITE LIGHTING PLAN
- E0.2 - ELECTRICAL SITE POWER PLAN
- E1.1 - GROUND FLOOR LIGHTING PLAN
- E1.2 - SECOND FLOOR LIGHTING PLAN
- E1.3 - THIRD FLOOR LIGHTING PLAN
- E2.1 - GROUND FLOOR POWER PLAN
- E2.2 - SECOND FLOOR POWER PLAN
- E2.3 - THIRD FLOOR POWER PLAN
- E2.4 - GROUND FLOOR HVAC POWER PLAN
- E2.5 - SECOND FLOOR HVAC POWER PLAN
- E2.6 - THIRD FLOOR HVAC POWER PLAN
- E3.1 - GROUND FLOOR AUXILIARY PLAN
- E3.2 - SECOND FLOOR AUXILIARY PLAN
- E3.3 - THIRD FLOOR AUXILIARY PLAN
- E4.1 - ELECTRICAL LARGE SCALE PLANS
- E5.1 - PANELBOARD SCHEDULES
- E5.2 - PANELBOARD SCHEDULES
- E5.3 - PANELBOARD SCHEDULES & SINGLE LINE DIAGRAM
- E6.1 - RISER DIAGRAMS & ELECTRICAL DETAILS
- E6.2 - ELECTRICAL DETAILS
- E7.1 - ELECTRICAL LIGHTING FIXTURE SCHEDULE & DETAILS
- E7.2 - ELECTRICAL LEGEND & NOTES

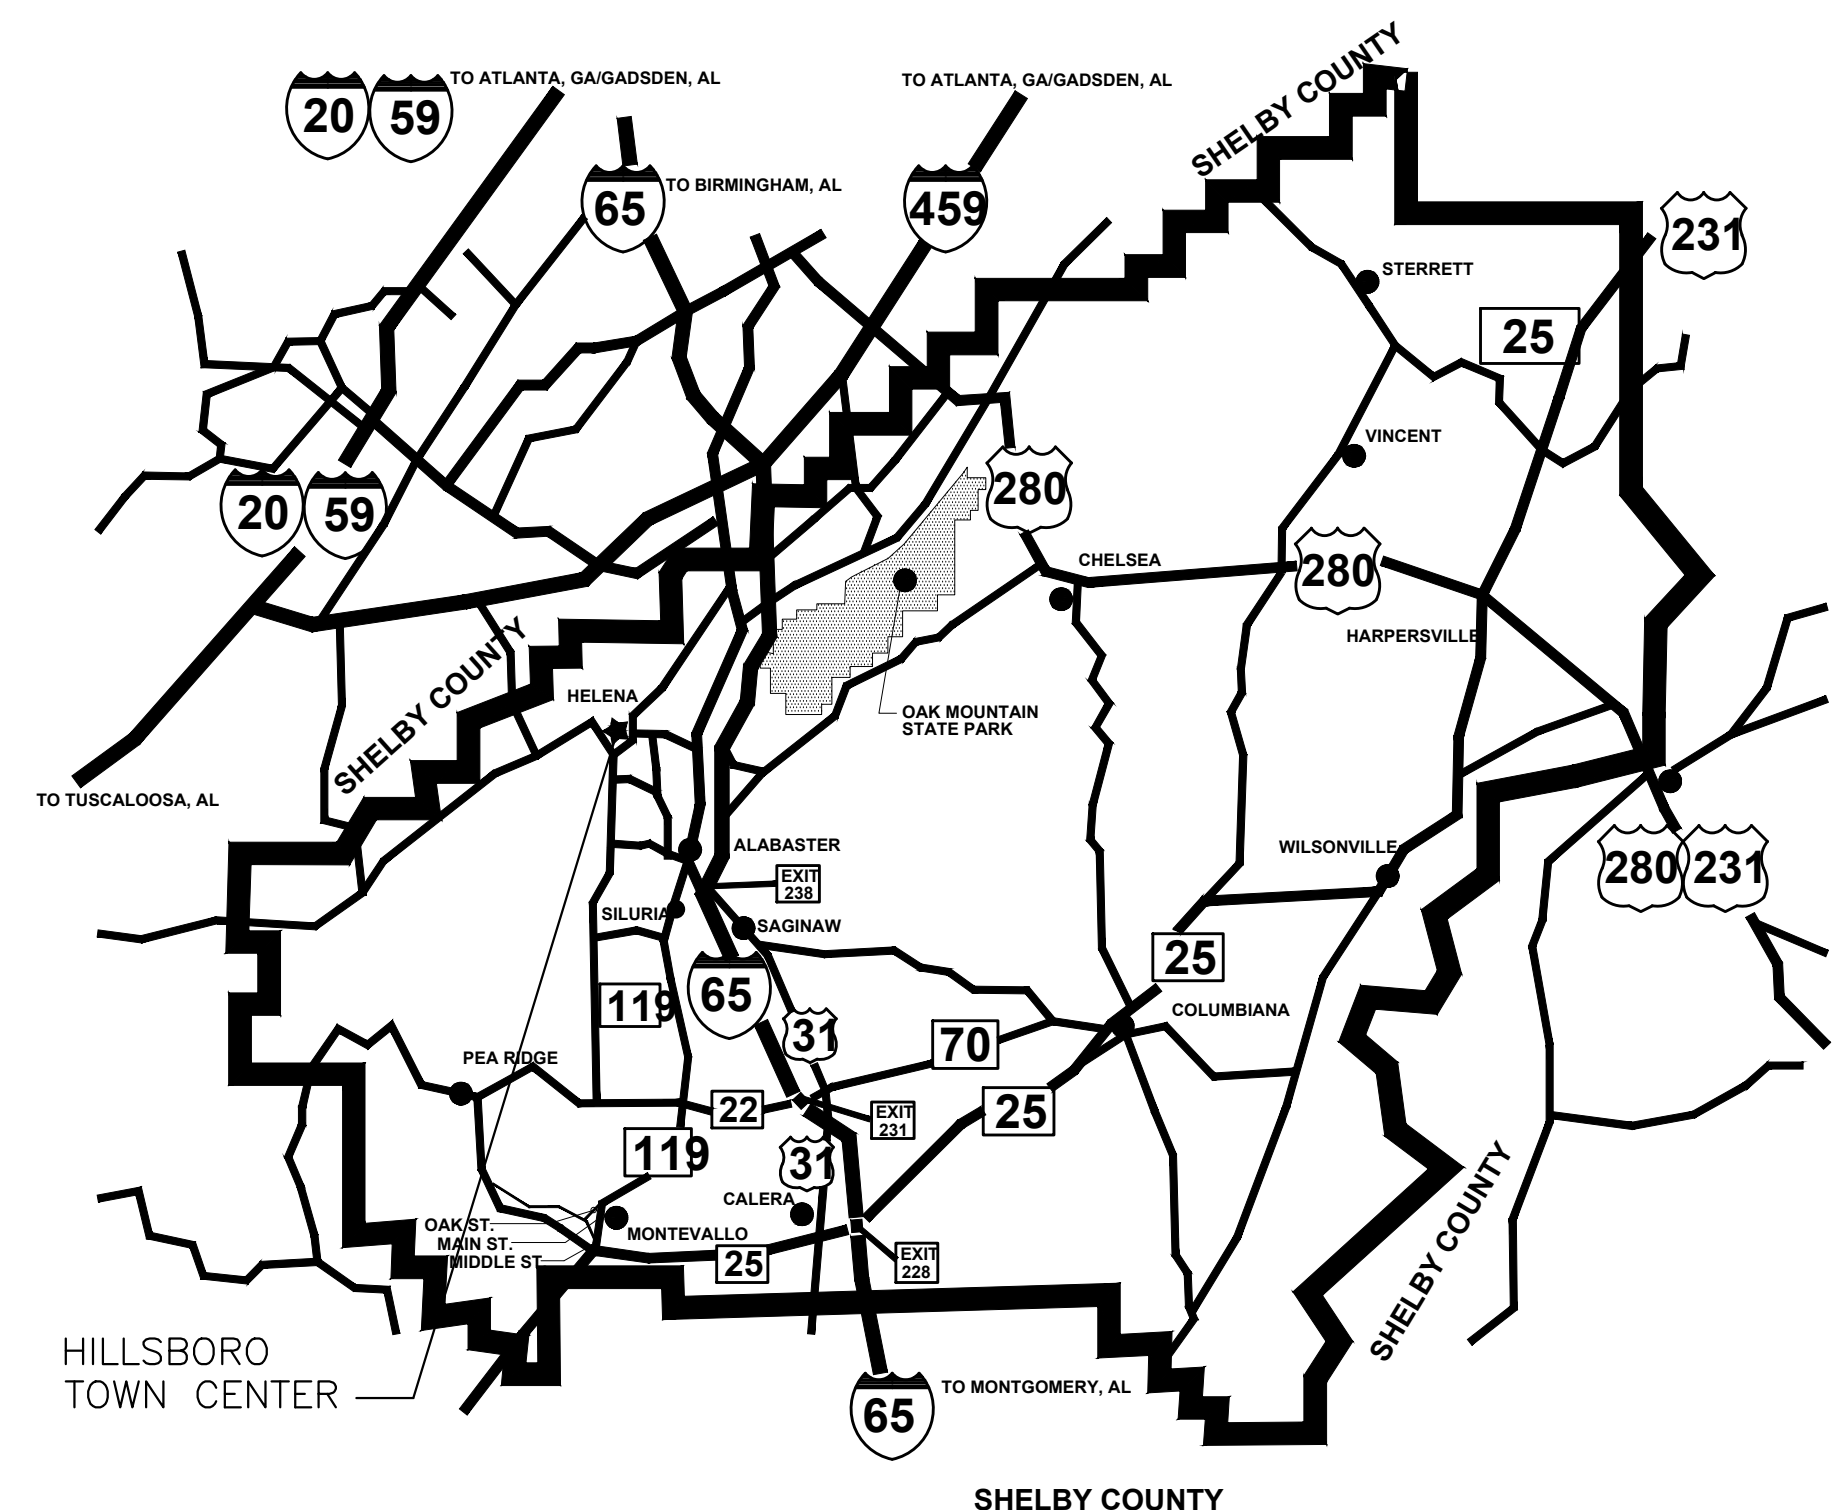

CITY OF HELENA, ALABAMA
HILLSBORO TOWN CENTER
HELENA, AL 35080

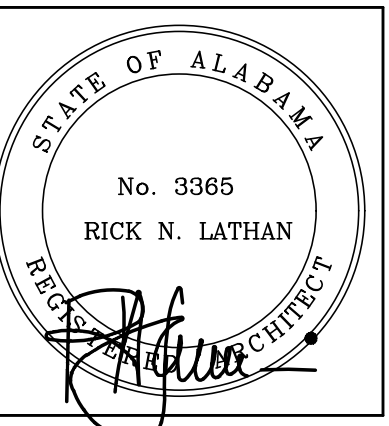

SHEET TITLE:
TITLE AND INDEX


PROJ. MGR.:	S.CALMA
DRAWN:	JT/PGC
<i>Rasco</i>	
DATE:	OCTOBER 31, 2023
REVISIONS	

JOB NO. 22-98

SHEET NO:


1

 OF 4





 NEW CITY HALL FOR THE
CITY OF HELENA, ALABAMA
HILLSBORO TOWN CENTER



SHEET TITLE:
FIRST FLOOR LIFE SAFETY
PLAN


PROJ. MGR.:	S.CALM
DRAWN:	H
fRasco	
DATE:	OCTOBER 31, 202
REVISIONS	

JOB NO. 22-98

SHEET NO:

LS1.1

 2 OF 4



1 FIRST FLOOR LIFE SAFETY PLAN

SCALE 1/8" = 1'-0"

NOTE: VESTIBULE 100 IS THREE STORIES AND ONLY OPEN TO THE FIRST AND SECOND FLOORS AND IS SEPARATED FROM THE THIRD IN ACCORDANCE WITH SECTION 713.4. PER SECTION 404.5 EXCEPTION (2) SMOKE CONTROL IS NOT REQUIRED. PER 404.6 EXCEPTION (4) SEPARATION BETWEEN THE FIRST AND SECOND FLOOR IS NOT REQUIRED.

- NOTE: MONUMENTAL STAIR AND NOT PART OF THE REQUIRED MEANS OF EGRESS. VERTICAL OPENING COMPLIES WITH SECTION 712.9 FOR A TWO STORY OPENING

2021 INTERNATIONAL BUILDING CODE RESEARCH FULLY SPRINKLERED				
OCCUPANCY CLASSIFICATION: MIXED NON-SEPARATED		GROUPS B AND A3		
TYPE OF CONSTRUCTION :		TYPE IIB		
FIRST FLOOR AREA:		14,571 S.F.		
TABLE 504.3 ALLOWABLE HEIGHT: GROUP A3	ALLOWABLE: 75'	ACTUAL : 55'		
TABLE 504.3 ALLOWABLE HEIGHT: GROUP B	ALLOWABLE: 75'	ACTUAL : 55'		
TABLE 504.4 ALLOWABLE NUMBER OF STORIES: GROUP A3	ALLOWABLE: 3	ACTUAL STORIES: 3		
TABLE 504.4 ALLOWABLE NUMBER OF STORIES: GROUP B	ALLOWABLE: 4	ACTUAL STORIES: 3		
TABLE 506.2 ALLOWABLE AREA: GROUP A3 - AREA PER STORY	ALLOWABLE: 28,500	ACTUAL: SEE ABOVE		
TABLE 506.2 ALLOWABLE AREA: GROUP B - ARE PER STORY	ALLOWABLE: 69,000	ACTUAL: SEE ABOVE		
TABLE 601 AND 705.2 FIRE-RESISTANCE RATING REQUIREMENTS FOR BUILDING ELEMENTS:	CONSTRUCTION TYPE:		IIB	
	STRUCTURAL FRAME:		0	
	BEARING WALLS:		0	
	T. 705.2	EXTERIOR:	< 5'	0
			≥ 5' < 10'	0
			≥ 10' < 30'	0
			≥ 30'	0
	INTERIOR:			
	NONBEARING WALLS:		0	
	T. 705.2	EXTERIOR:	< 5'	0
			≥ 5' < 10'	0
			≥ 10' < 30'	0
			≥ 30'	0
	INTERIOR:			0
FLOOR CONSTRUCTION:		0		
ROOF CONSTRUCTION:		0		
TABLE 1020.2 CORRIDOR FIRE-RESISTANCE RATING PARTITIONS AND OPENING PROTECTIVES	GROUPS B AND A3 SPRINKLERED		0	

DOOR/WINDOW RATING LEGEND

(20)	20 MINUTE DOOR AND FRAME	(60)	60 MINUTE DOOR AND FRAME
(45)	45 MINUTE DOOR AND FRAME	(90)	90 MINUTE DOOR AND FRAME

WALL TYPE LEGEND

----	1 HR WALL
----	2 HR WALL
S-S-S-S-S-S-S-S-S-S-S-S-S-S-	SMOKE BARRIER
SP-SP-SP-SP-SP-SP-SP-SP-	SPRINKLER WASHED WALL

LIFE SAFETY NOTES

 FIRE EXTINGUISHER AND CABINET (PROVIDE FIRE RATED CABINETS IN RATED WALLS.)	
 FIRE EXTINGUISHER	 ACCESSIBLE  EXIT  EXIT CAPACITY

EXTEND AND KEY ALL RATED WALLS TO SHAFT WALL SYSTEM, AND/OR BOTTOM OF ROOF ASSEMBLY
--

STENCIL LABEL ALL RATED WALLS & DRAFT STOPS
ABOVE CEILING EACH SIDE @ 20'-0" O.C. MAX.

ALL RATED DOORS AND FRAMES TO BE LABELED WITH EMBOSSED LABELS INDICATING RATING IN MINUTES

COORDINATE EXACT PLACEMENT OF FIRE EXTINGUISHERS WITH ARCHITECT PRIOR TO INSTALLATION

HE - HORIZONTAL EXIT	
----------------------	--

FB - FIRE BARRIER	
FP - FIRE PARTITION	

FP - FIRE PARTITION	
FW - FIRE WALL	

TRAVEL DISTANCE — < — < — < — < — PATH

_____ DIRECTION

EGRESS
CALCULATION

LOAD FACTOR: 300 G — N = NET
OCCUPANT LOAD 35 — G = GROSS

_____ COORDINATING LOAD _____

OCCUPANCY USE LEGEND

 B GROUP B	 A3 GROUP A3
--	--


CHAPTER 29 - PLUMBING SYSTEMS

OCCUPANCY		WATERCLOSETS				LAVATORIES				DRINKING FOUNTAINS		SERVICE SINKS	
USE	LOAD	RATIO	MALE	RATIO	FEMALE	RATIO	MALE	RATIO	FEMALE	RATIO	ALL		ALL
A3	373.26	1/125	1.49	1/65	2.87	1/200	.93	1/200	.93	1/500	.75		
B	96.36	1/225 FIRST 1/50 REMAINDER EXCEEDING 50.	1.93	1/25 FIRST 1/50 REMAINDER EXCEEDING 50.	1.93	1/40 FIRST 1/60 EXCEED 80.	1.2	1/40 FIRST 1/60 EXCEED 80.	1.2	1/100	.96		
REQUIRED TOTALS			3.42		4.8		2.13		2.13		1.71		1
PROVIDED TOTALS			15		16		11		12		4		2

NOTE: PLUMBING FIXTURE CALCULATIONS ARE BASED ON BUILD OUT OF FIRST AND SECOND FLOORS ONLY



 NEW CITY HALL FOR THE
CITY OF HELENA, ALABAMA
HILLSBORO TOWN CENTER
HELENA, AL 35080



SHEET TITLE:
SECOND FLOOR LIFE SAFETY
PLAN



PROJ. MGR.:	S.CALM
DRAWN:	H
fRasco	
DATE:	OCTOBER 31, 202
REVISIONS	

JOB NO. 22-98

SHEET NO:

LS1.2

 3 OF 4

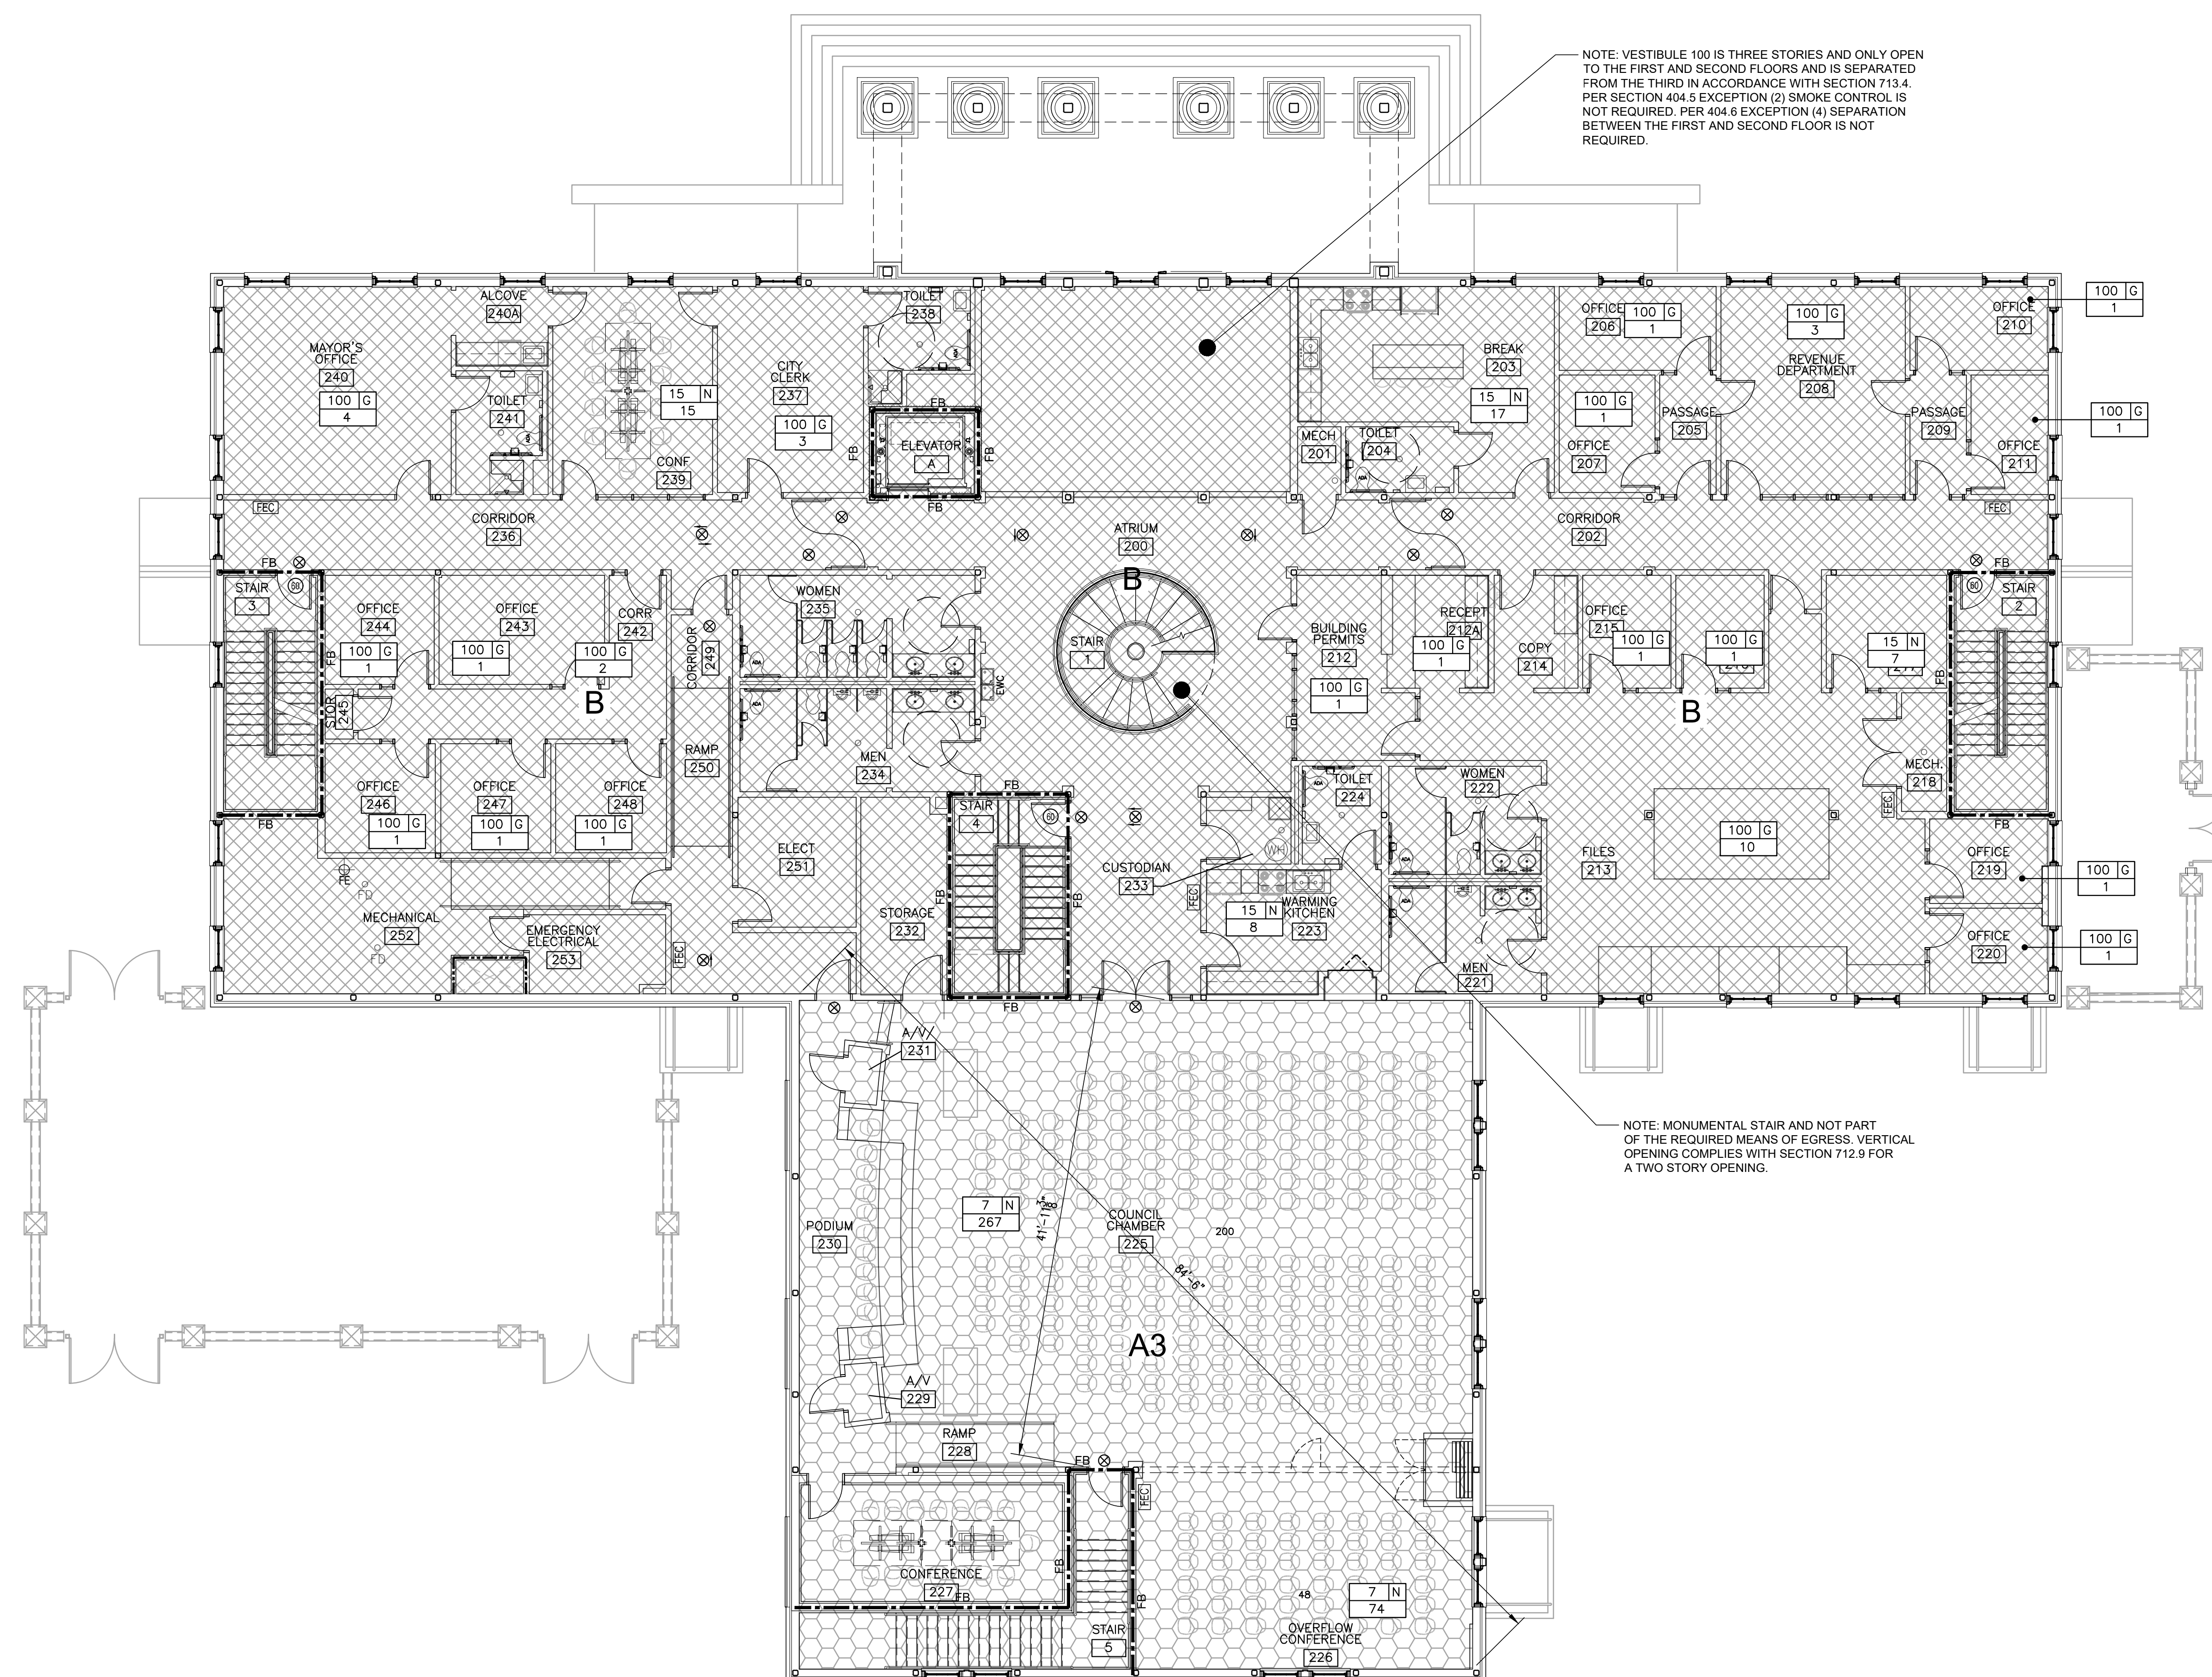

2021 INTERNATIONAL BUILDING CODE RESEARCH FULLY SPRINKLERED						
OCCUPANCY CLASSIFICATION: MIXED NON-SEPARATED PER SECTION 508.3		GROUPS B AND A3				
TYPE OF CONSTRUCTION :		TYPE IIB				
SECOND FLOOR AREA:		13,700 S.F.				
TABLE 504.3 ALLOWABLE HEIGHT: GROUP A3	ALLOWABLE: 7'5"	ACTUAL : 55'				
TABLE 504.3 ALLOWABLE HEIGHT: GROUP B	ALLOWABLE: 7'5"	ACTUAL : 55'				
TABLE 504.4 ALLOWABLE NUMBER OF STORIES: GROUP A3	ALLOWABLE: 3	ACTUAL STORIES: 3				
TABLE 504.4 ALLOWABLE NUMBER OF STORIES: GROUP B	ALLOWABLE: 4	ACTUAL STORIES: 3				
TABLE 506.2 ALLOWABLE AREA: GROUP A3 - AREA PER STORY	ALLOWABLE: 28,500	ACTUAL: SEE ABOVE				
TABLE 506.2 ALLOWABLE AREA: GROUP B - AREA PER STORY	ALLOWABLE: 69,000	ACTUAL: SEE ABOVE				
TABLE 601 AND 705.2 FIRE-RESISTANCE RATING REQUIREMENTS FOR BUILDING ELEMENTS:		CONSTRUCTION TYPE:		IIB		
		STRUCTURAL FRAME:		0		
		BEARING WALLS:		0		
		T. 705.2	EXTERIOR:	< 5'	11	
				≥ 5' < 10'	11	
				≥ 10' < 30'	0	
				≥ 30'	0	
		INTERIOR:				0
		NONBEARING WALLS:		0		
		T. 705.2	EXTERIOR:	< 5'	11	
≥ 5' < 10'	11					
≥ 10' < 30'	0					
≥ 30'	0					
INTERIOR:		0				
FLOOR CONSTRUCTION:		0				
ROOF CONSTRUCTION:		0				
TABLE 1020.2 CORRIDOR FIRE-RESISTANCE RATING PARTITIONS AND OPENING PROTECTIVES		GROUPS B AND A3 SPRINKLERED		0		

DOOR/WINDOW RATING LEGEND	
(20)	20 MINUTE DOOR AND FRAME
(45)	45 MINUTE DOOR AND FRAME
(60)	60 MINUTE DOOR AND FRAME
(90)	90 MINUTE DOOR AND FRAME

WALL TYPE LEGEND	
	1 HR WALL
	2 HR WALL
	SMOKE BARRIER
	SPRINKLER WASHED WALL

LIFE SAFETY NOTES					
FES	FIRE EXTINGUISHER AND CABINET (PROVIDE FIRE RATED CABINETS IN RATED WALLS.)				
	FIRE EXTINGUISHER				
	EXIT SIGN DIRECTION				
EXTEND AND KEY ALL RATED WALLS TO SHAFT WALL SYSTEM, AND/OR BOTTOM OF ROOF ASSEMBLY					
STENCIL LABEL ALL RATED WALLS & DRAFT STOPS Above ceiling each side @ 20" O" C. MAX.					
ALL RATED DOORS AND FRAMES TO BE LABELED WITH EMBOSSED LABELS INDICATING RATING IN MINUTES					
COORDINATE EXACT PLACEMENT OF FIRE EXTINGUISHERS WITH ARCHITECT PRIOR TO INSTALLATION					
HE - HORIZONTAL EXIT					
FB - FIRE BARRIER					
FP - FIRE PARTITION					
FW - FIRE WALL					
START					
TRAVEL DISTANCE PATH DIRECTION					
EGRESS CALCULATION	LOAD FACTOR: <table style="width: 100%; border-collapse: collapse;"> <tr> <td style="border: 1px solid black; width: 50%; text-align: center;">300 / G</td> <td style="width: 50%;"></td> </tr> <tr> <td style="border: 1px solid black; text-align: center;">35</td> <td></td> </tr> </table> OCCUPANT LOAD	300 / G		35	
300 / G					
35					
N = NET G = GROSS					


OCCUPANCY USE LEGEND

 B	 A3
GROUP B	GROUP A3

 **1 SECOND FLOOR LIFE SAFETY PLAN**
SCALE 1/8" = 1'-0"



 NEW CITY HALL FOR THE
CITY OF HELENA, ALABAMA
HILLSBORO TOWN CENTER
HELENA, AL 35080



SHEET TITLE:
THIRD FLOOR LIFE SAFETY
PLAN PLAN

PROJ. MGR.:	S.CALMA
DRAWN:	HR
<i>Rasco</i>	
DATE:	OCTOBER 31, 2023
REVISIONS	



JOB NO. 22-98

SHEET NO:

LS1.3


4 OF 4

OCCUPANCY USE LEGEND	
 B GROUP B	 A3 GROUP A3

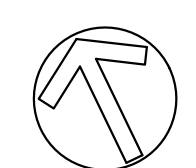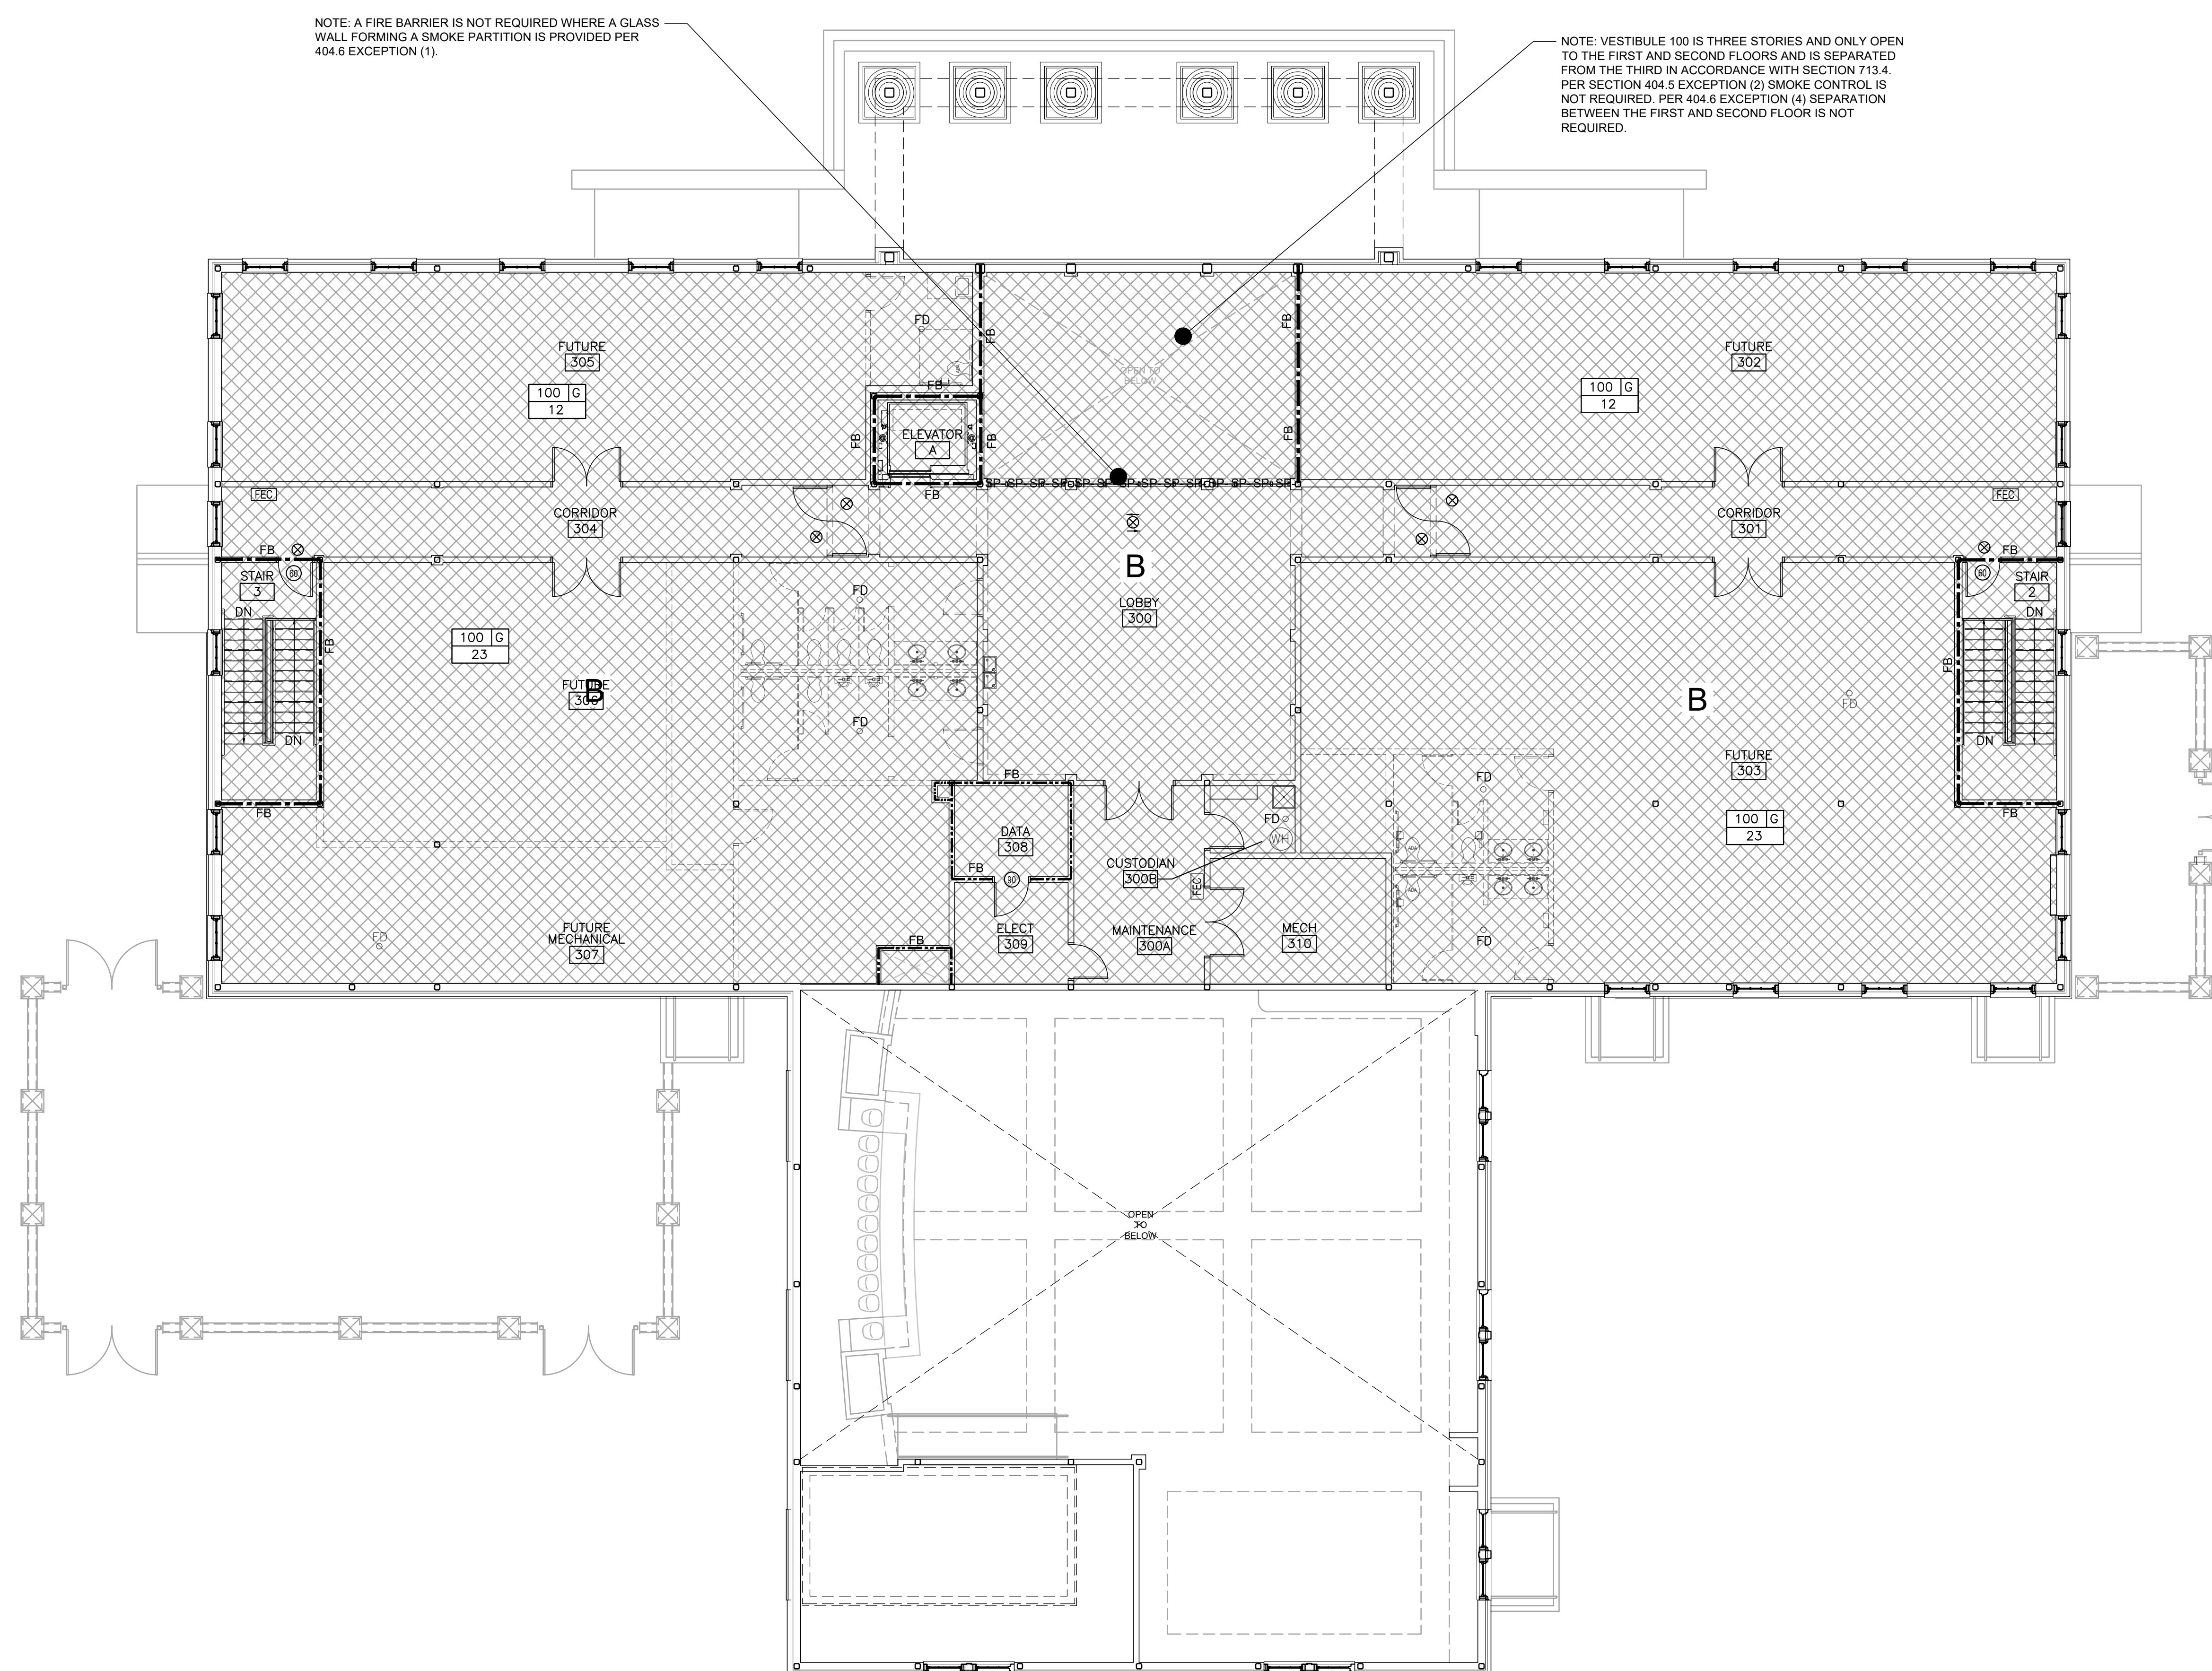

1 THIRD FLOOR LIFE SAFETY PLAN

SCALE: 1/8" = 1'-0"

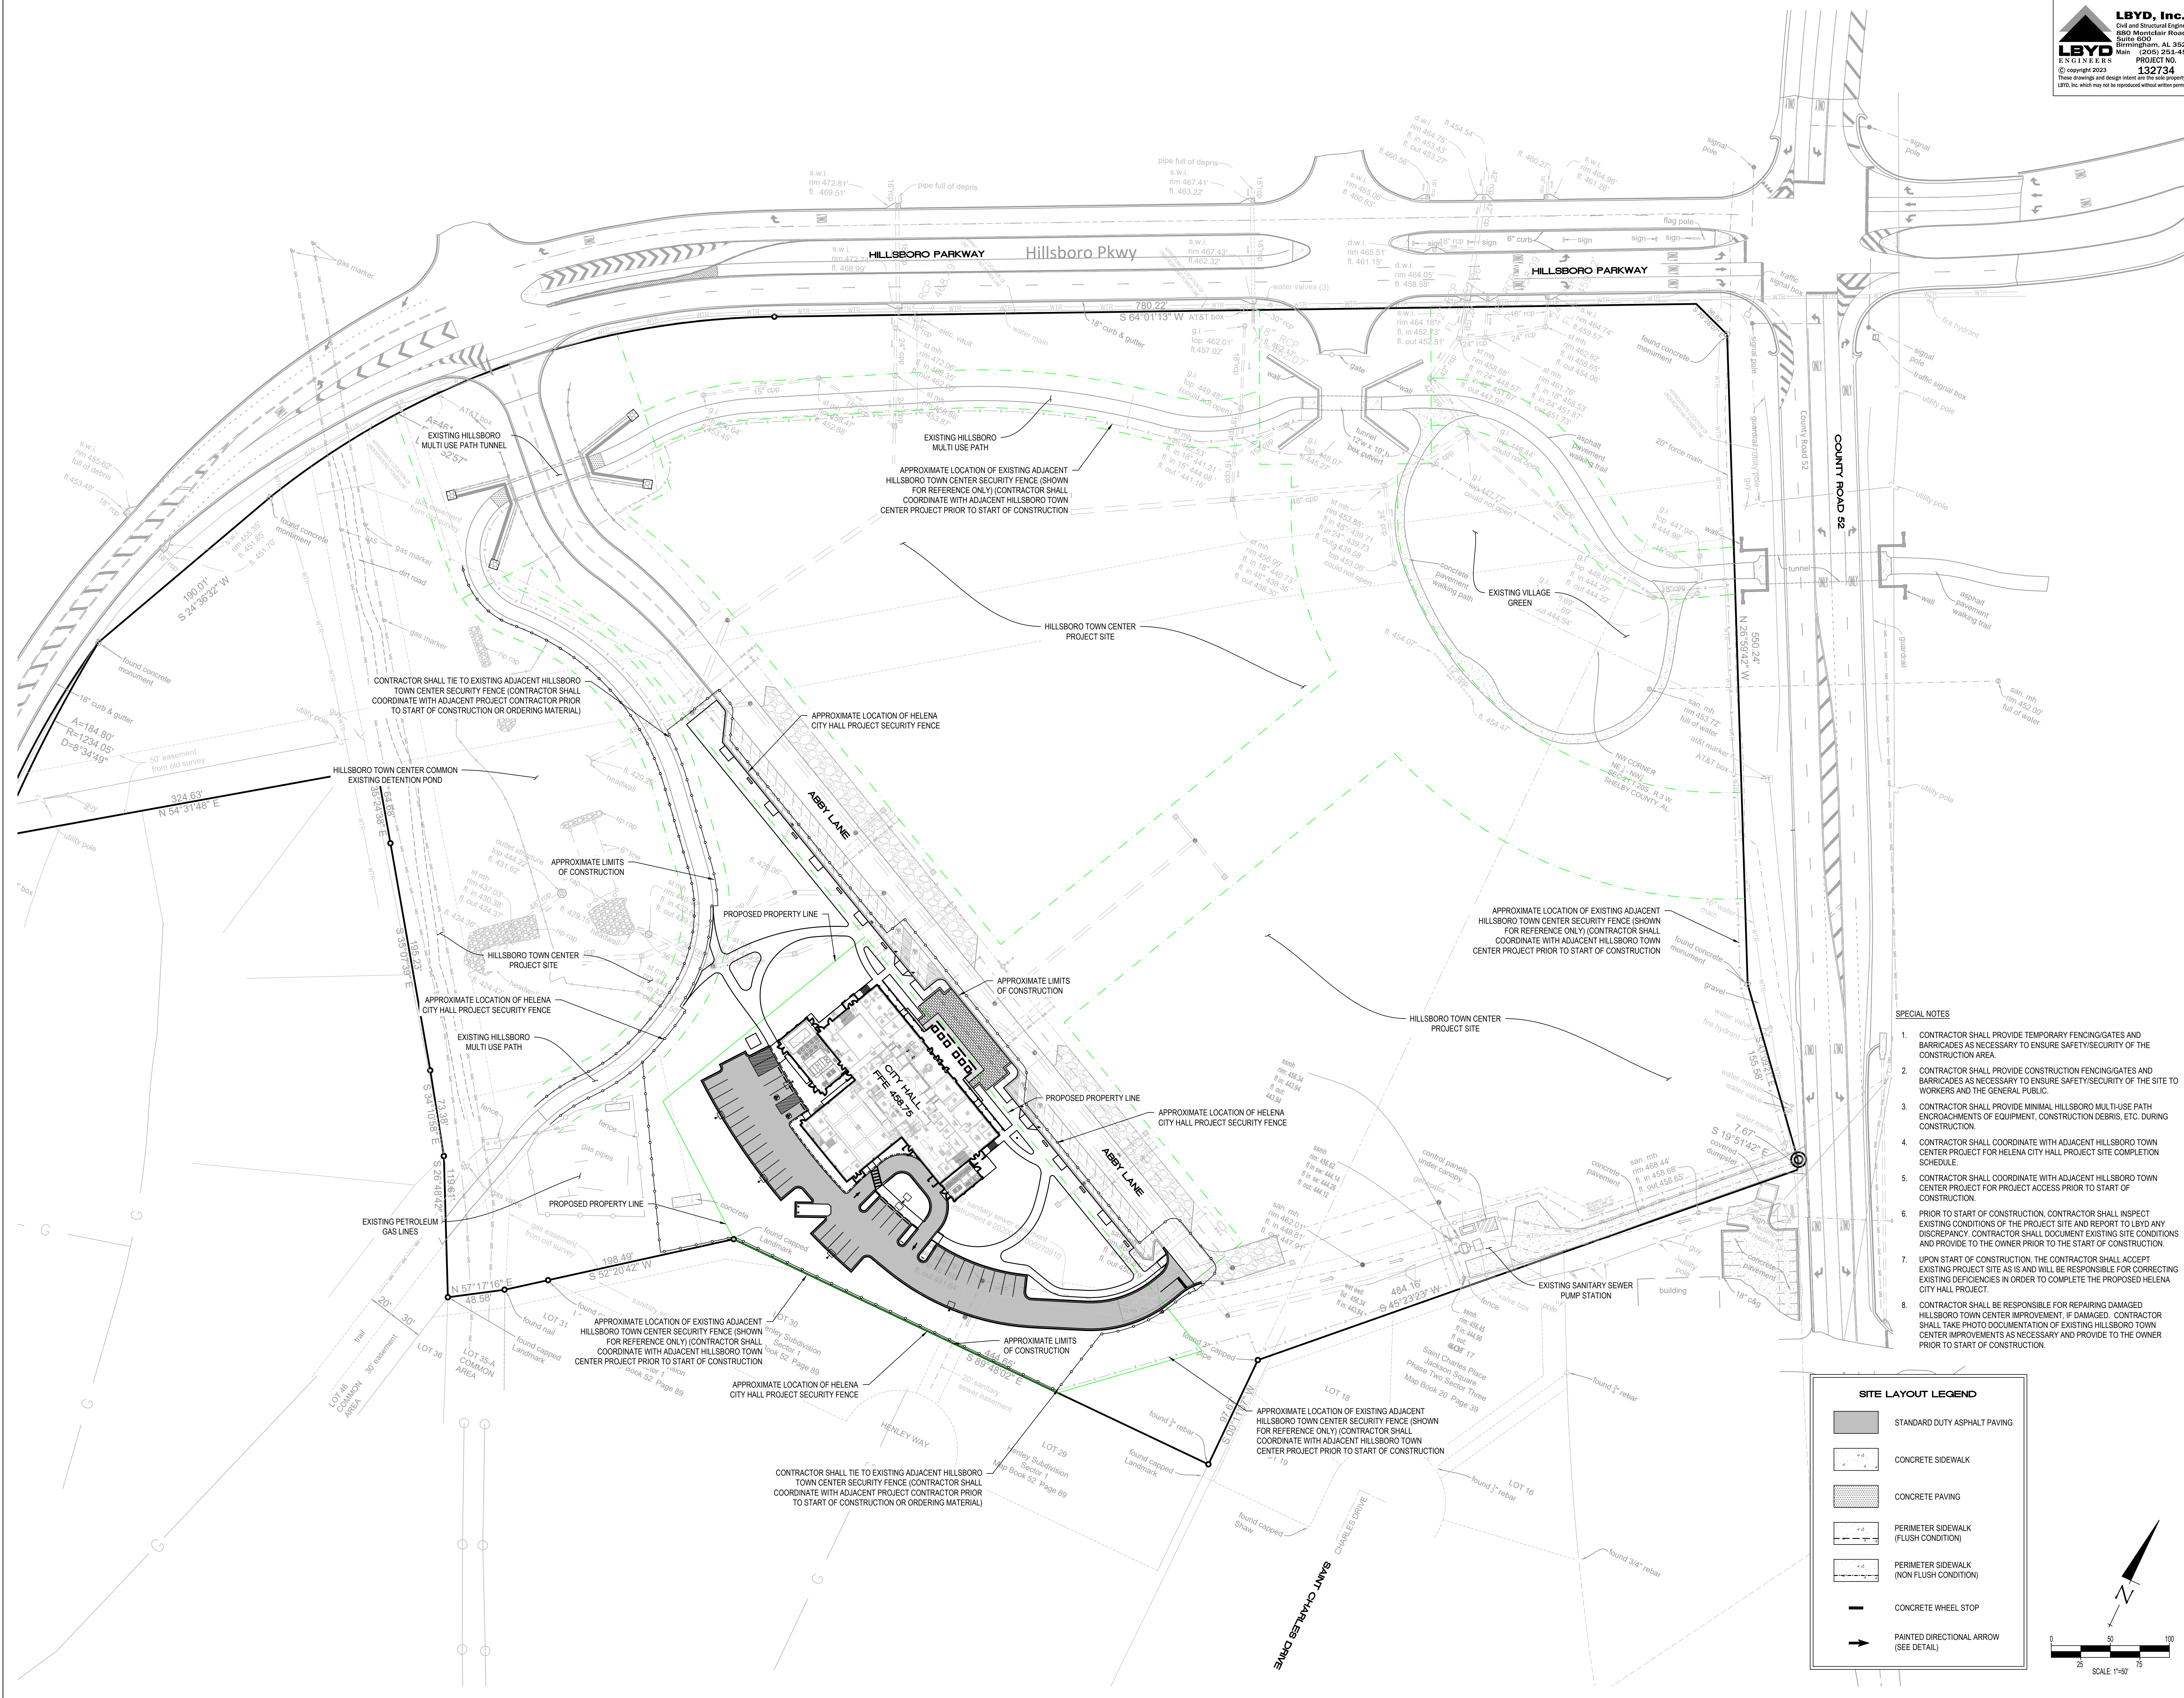


SPECIAL NOTES

1. CONTRACTOR SHALL PROVIDE TEMPORARY FENCING/GATES AND BARRICADES AS NECESSARY TO ENSURE SAFETY/SECURITY OF THE CONSTRUCTION AREA.
2. CONTRACTOR SHALL PROVIDE CONSTRUCTION FENCING/GATES AND BARRICADES AS NECESSARY TO ENSURE SAFETY/SECURITY OF THE SITE TO WORKERS AND THE GENERAL PUBLIC.
3. CONTRACTOR SHALL PROVIDE MINIMAL HILLSBORO MULTI-USE PATH ENCROACHMENTS OF EQUIPMENT, CONSTRUCTION DEBRIS, ETC. DURING CONSTRUCTION.
4. CONTRACTOR SHALL COORDINATE WITH ADJACENT HILLSBORO TOWN CENTER PROJECT FOR HELENA CITY HALL PROJECT SITE COMPLETION SCHEDULE.
5. CONTRACTOR SHALL COORDINATE WITH ADJACENT HILLSBORO TOWN CENTER PROJECT FOR PROJECT ACCESS PRIOR TO START OF CONSTRUCTION.
6. PRIOR TO START OF CONSTRUCTION, CONTRACTOR SHALL INSPECT EXISTING CONDITIONS OF THE PROJECT SITE AND REPORT TO LBVD ANY DISCREPANCY. CONTRACTOR SHALL DOCUMENT EXISTING SITE CONDITIONS AND PROVIDE TO THE OWNER PRIOR TO THE START OF CONSTRUCTION.
7. UPON START OF CONSTRUCTION, THE CONTRACTOR SHALL ACCEPT EXISTING PROJECT SITE AS IS AND WILL BE RESPONSIBLE FOR CORRECTING EXISTING DEFICIENCIES IN ORDER TO COMPLETE THE PROPOSED HELENA CITY HALL PROJECT.
8. CONTRACTOR SHALL BE RESPONSIBLE FOR REPAIRING DAMAGED HILLSBORO TOWN CENTER IMPROVEMENTS, IF DAMAGED. CONTRACTOR SHALL TAKE PHOTO DOCUMENTATION OF EXISTING HILLSBORO TOWN CENTER IMPROVEMENTS AS NECESSARY AND PROVIDE TO THE OWNER PRIOR TO START OF CONSTRUCTION.

SITE LAYOUT LEGEND

- STANDARD DUTY ASPHALT PAVING
- CONCRETE SIDEWALK
- CONCRETE PAVING
- PERIMETER SIDEWALK (FLUSH CONDITION)
- PERIMETER SIDEWALK (NON FLUSH CONDITION)
- CONCRETE WHEEL STOP
- PAINTED DIRECTIONAL ARROW (SEE DETAIL)


NEW CITY HALL FOR THE
CITY OF HELENA, ALABAMA
HILLSBORO TOWN CENTER
HELENA, AL 35090

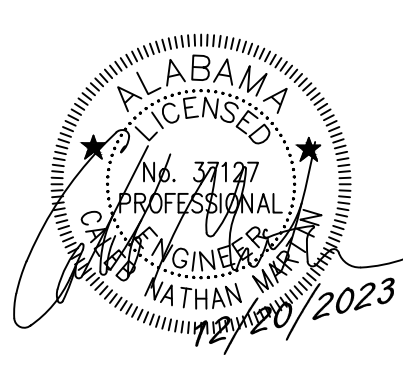

SHEET TITLE:
OVERALL EXISTING
CONDITIONS PLAN

PROJ. MGR.: S.CALMA
DRAWN:
DATE: OCTOBER 31, 2023
REVISIONS

JOB NO. 22-98
SHEET NO:
C0.2
2 OF 12

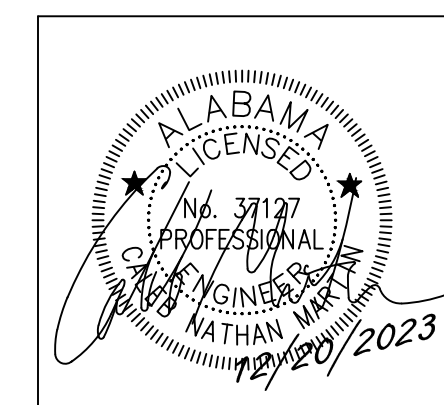

SHEET TITLE:


SITE LAYOUT
PLAN


PROJ. MGR.:	S.CALMA
DRAWN:	
DATE:	OCTOBER 31, 2023
REVISIONS	

JOB NO. 22-98


SHEET NO:

C2.0
4 OF 12

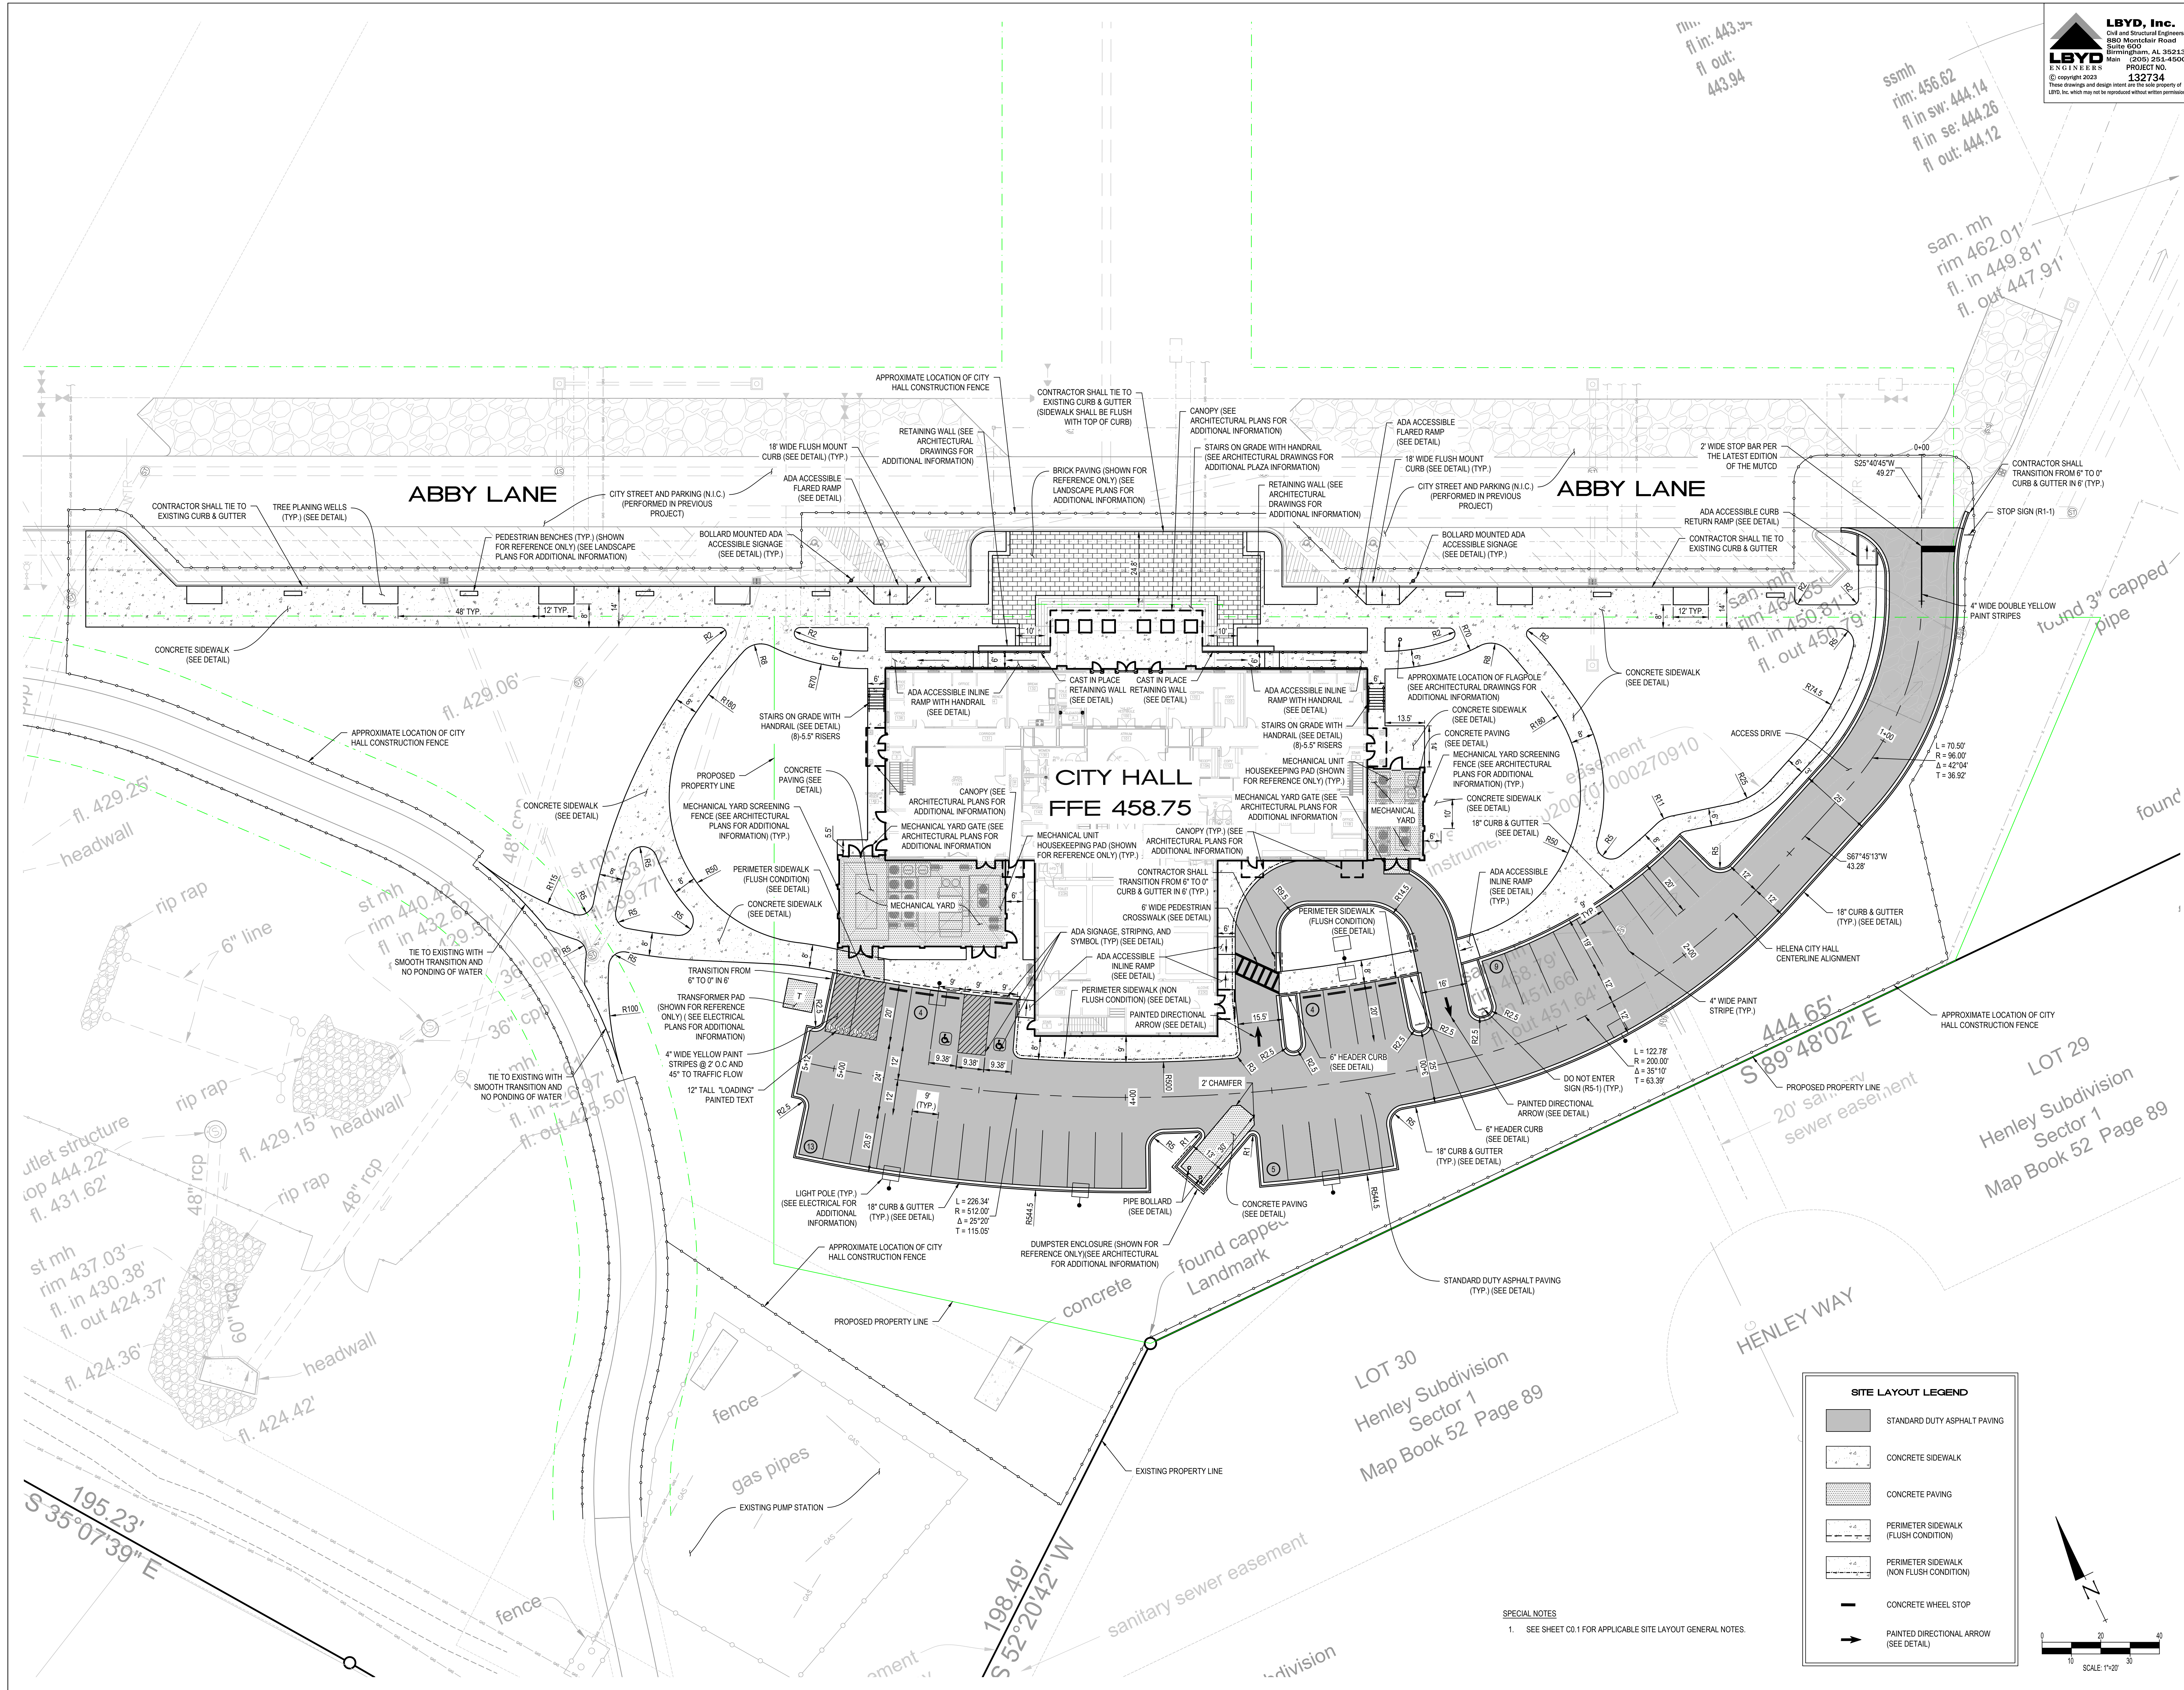

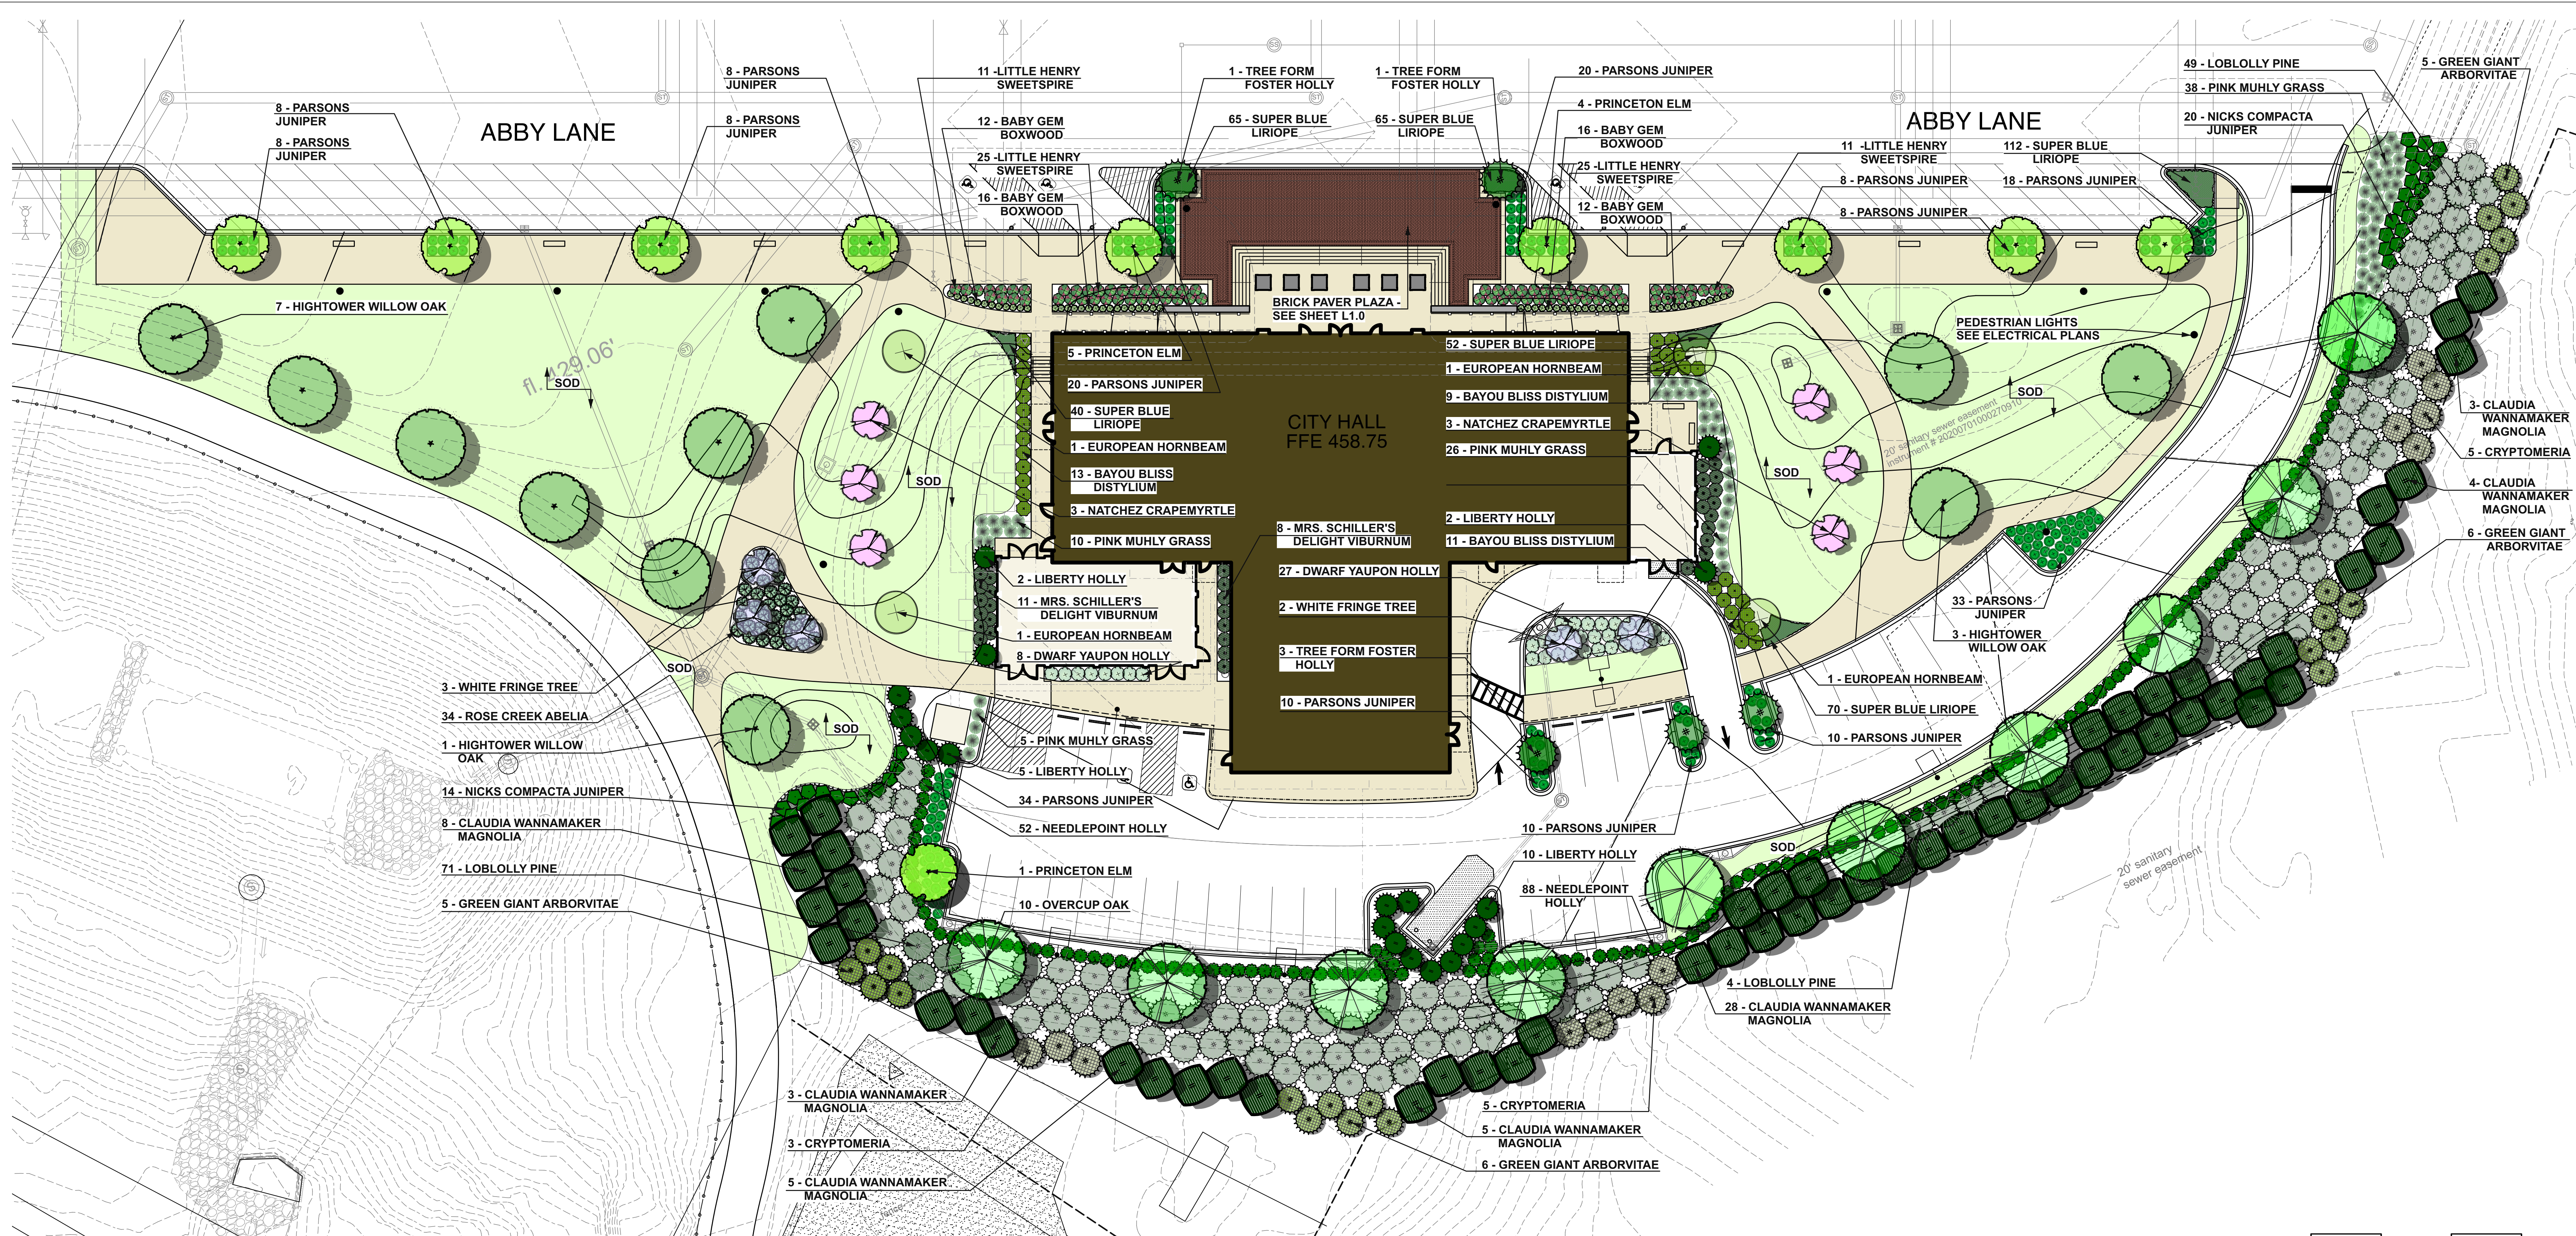

PLANTING PLAN

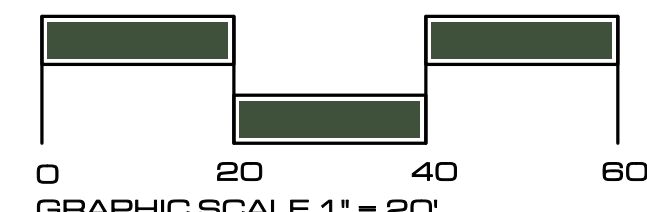

PLANT MATERIAL SCHEDULE


QTY.	BOTANICAL NAME	COMMON NAME	SIZE	ROOT	REMARKS
TREES					
56	Buxus microphylla 'Baby Gem'	Baby Gem Boxwood	12" ht. min.	Cont.	Limbed up @ 6' ht.
4	Carpinus betulus 'Fastigiata'	European Hornbeam	3'-3 1/2" cal.	B&B	Limbed up @ 6' ht.
5	Chionanthus virginicus	White Fringe Tree	8' ht.	B&B	Multi-trunked, 3-5 Trunks
13	Cryptomeria radicans	Cryptomeria	10'-12' ht.	B&B	Full to Ground, Matched
5	Ilex attenuata 'Fosteri'	Foster Holly	10' ht.	B&B	Standard, Tree Form, limbed up 5'
6	Lagerstroemia indica 'Natchez'	Natchez Crape myrtle	8'-10' ht.	B&B	Multi-trunked, 3-5 Trunks
56	Magnolia grandiflora 'Claudia Wannamaker'	Claudia Wannamaker Magnolia	12'-14' ht.	B&B	Full to Ground, Matched
124	Pinus taeda	Loblolly Pine	5'-6' ht.	Cont.	8' O.C.
10	Quercus lyrata 'Highbeam'	Highbeam Overcup Oak	3'-3 1/2" cal.	B&B	Matched, Full Head
11	Quercus phellos 'Hightower'	Hightower Willow Oak	3'-3 1/2" cal.	B&B	Matched, Full Head
22	Thuja occidentalis 'Green Giant'	Green Giant Arborvitae	10'-12' ht.	B&B	Matched, full to ground
10	Ulmus americana 'Princeton'	Princeton Elm	3'-3 1/2" cal.	B&B	Matched, Full Head
SHRUBS					
32	Distylium BUDY01 Hybrid PP32816	Bayou Bliss Distylium	15'-18" sp.	Cont.	4'0" O.C.
140	Ilex cornuta 'Needlepoint'	Needlepoint Holly	18"-24" ht.	Cont.	4'0" O.C.
35	Ilex vomitoria 'Nana'	Dwarf Yaupon Holly	15'-18" sp.	Cont.	4'0" O.C.
19	Ilex x Liberty	Liberty Holly	7'-8' ht.	B&B	7'0" O.C.
72	Itea virginica 'Little Henry'	Little Henry Virginia Sweetpire	15'-18" ht.	B&B	3.5' O.C.
34	Juniperus chinensis 'Nicks Compacta'	Nicks Compacta Juniper	15'-18" sp.	Cont.	4'0" O.C.
203	Juniperus squamata expansa	Parsons Juniper	15'-18" sp.	Cont.	3'0" O.C.
32	Viburnum ovatum 'Mrs Schiller's Delight'	Mrs. Schiller's Delight Viburnum	15'-18" sp.	Cont.	4.5' O.C.
SHRUBS					
404	Liriodendron 'Super Blue'	Super Blue Liriope	1 Gallon	Cont.	12" O.C.
GRASSES					
79	Muhlenbergia capillaris	Pink Muhly Grass	3 Gal.	Cont.	4'0" O.C.
As Required	Zoysia emerald	Emerald Zoysia			

PLANTING NOTES:

- CONTRACTOR TO VERIFY ALL PLANT MATERIAL QUANTITIES AND PLANTING AREA DIMENSIONS PRIOR TO BEGINNING PLANTING. PROVIDE QUANTITIES AS REQUIRED TO MEET DESIGN INTENT.
- GRAFTED PLANT MATERIAL IS NOT ACCEPTABLE EXCEPT FOR TREES.
- DUE TO MODIFICATIONS MADE DURING CONSTRUCTION, SITE CONDITIONS MAY VARY FROM THOSE SHOWN. CONTRACTOR TO VERIFY ALL SUCH CONDITIONS TO HIS SATISFACTION. NO CHANGE IN CONTRACT PRICE WILL BE GRANTED FOR FAILURE TO OBSERVE THIS REQUIREMENT.
- THE CONTRACTOR SHALL, FOR HIS OWN PROTECTION, VERIFY THE PRESENCE AND LOCATION OF ALL UTILITIES PRIOR TO COMMENCING ANY CONSTRUCTION.
- FLAG ALL TREE LOCATIONS AND PAINT ALL BEDLINES FOR LANDSCAPE ARCHITECT'S ON-SITE REVIEW AND APPROVAL PRIOR TO BEGINNING PLANTING OPERATIONS.**
- ALL NEW TREES THAT ARE PLANTED ADJACENT TO ACCESSIBLE ROUTES AND WILL AT SOME POINT OVERHANG SIDEWALK TO BE LIMBED UP A MINIMUM OF 80" FROM THE ELEVATION OF THE SIDEWALK. ALL EXISTING TREES TO BE PRUNED TO 80" CLEARANCE THAT DO NOT ALREADY MEET THIS REQUIREMENT.**
- ALL PLANTED AREAS SHALL RECEIVE SHREDDED PINE BARK MULCH TO A DEPTH OF 3" AFTER SETTLEMENT.
- PLANTED SLOPES GREATER THAN 3:1 TO RECEIVE PINE STRAW MULCH TO 3" DEPTH AFTER SETTLEMENT.
- ALL SHRUB AREAS SHALL RECEIVE TOPSOIL TO A MINIMUM DEPTH OF 8". ALL SODDED AREAS SHALL RECEIVE TOPSOIL TO A MINIMUM DEPTH OF 4", UNLESS DIRECTED OTHERWISE.
- FERTILIZATION SCHEDULE: AMEND PLANTING MIX OF EACH PLANT WITH FERTILIZER AS FOLLOWS:


PLANTING	AMOUNT PER PLANT	TYPE
#1 POT	1/4 CUP	6-12-12 OR 5-10-10
#2 POT	1/2 CUP	6-12-12 OR 5-10-10
#3 POT	3/4 CUP	6-12-12 OR 5-10-10

 FLOWERING/ SHADE TREE 1 CUP PER 1/2" CAL. 6-12-12 OR 5-10-10
- REMOVE BASE MATERIAL FROM PLANTING AREAS BEFORE PLANTING OPERATIONS BEGIN.
- REPLACE ALL EXISTING SOD THAT HAS BEEN DAMAGED DURING CONSTRUCTION.
- COORDINATE PLANTING INSTALLATION AROUND IN-GROUND LIGHTING FIXTURES.
- NO PLANT MATERIAL WILL BE SET WITH ROOT CROWN LOWER THAN SURROUNDING GRADE. SET TREES WITH ROOT CROWN 2" TO 4" ABOVE SURROUNDING GRADE; SET SHRUBS WITH ROOT CROWN 1"-2" ABOVE SURROUND GRADE.
- PLANTING PLAN IS A GRAPHIC REPRESENTATION OF LOCATION OF PLANT MATERIALS. CONTRACTOR TO INSTALL PLANT MATERIALS ACCORDING TO DIRECTIONS FOUND IN DETAIL 5/L1.2.
- ALLEVIATE COMPACTION OF SOIL IN PROPOSED BED AND SOD AREAS PRIOR TO PLANTING.
- USE ALL MEANS NECESSARY TO CONTROL DUST ON AND NEAR ALL OFF-SITE AREAS.
- CLEAN ALL PAVED SURFACES OF DEBRIS, MUD, DUST, MULCH, ETC. INCURRED DURING INSTALLATION.

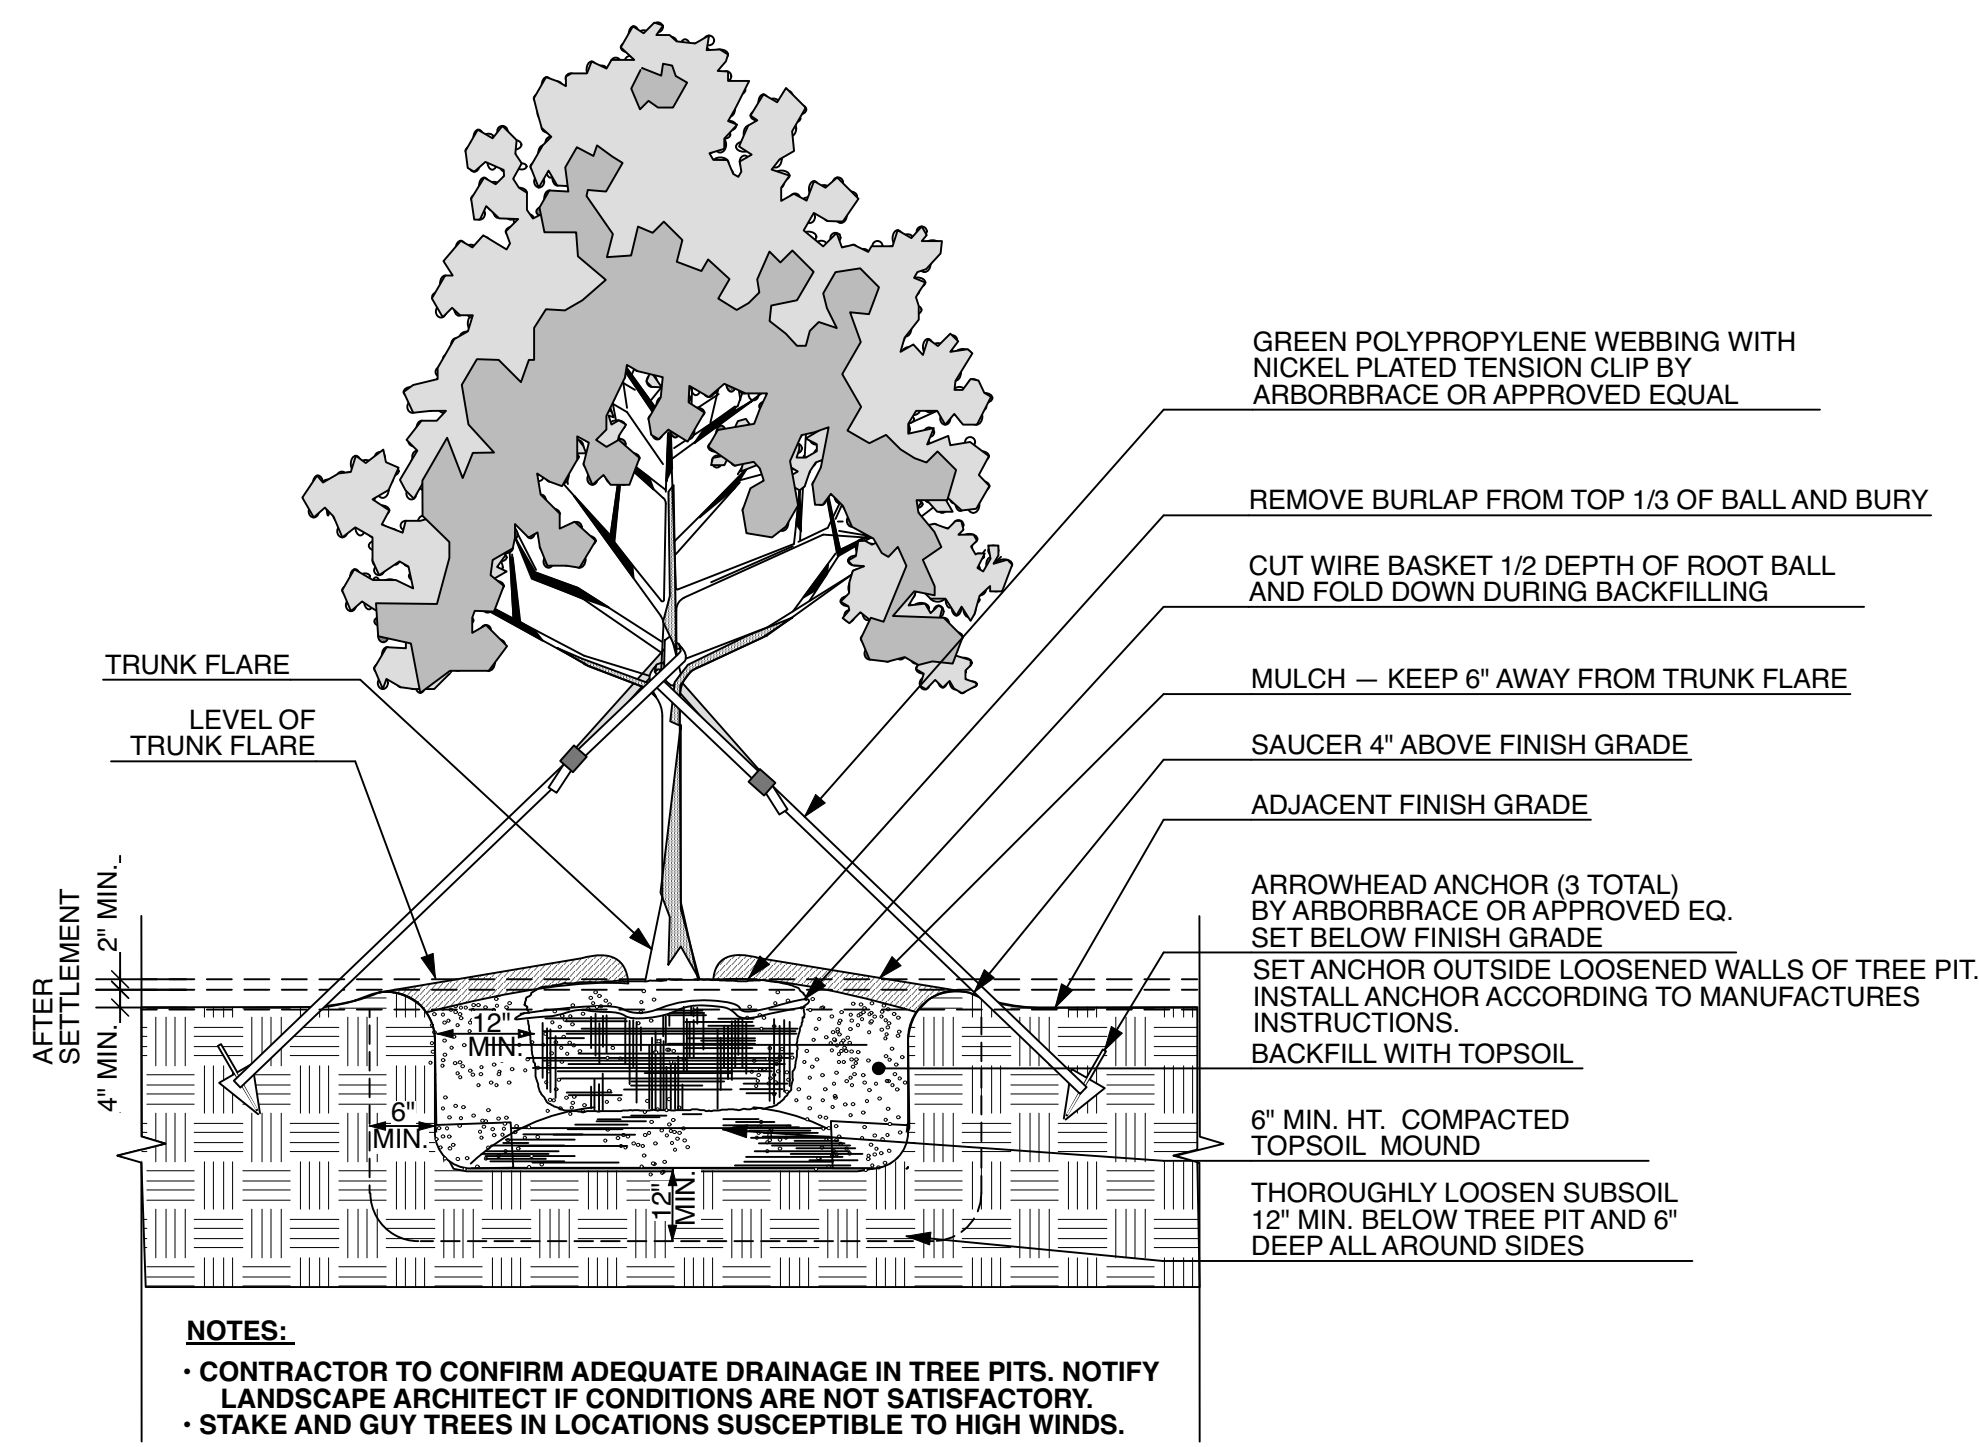


1 B&B TREE PLANTING DETAIL

NOT TO SCALE

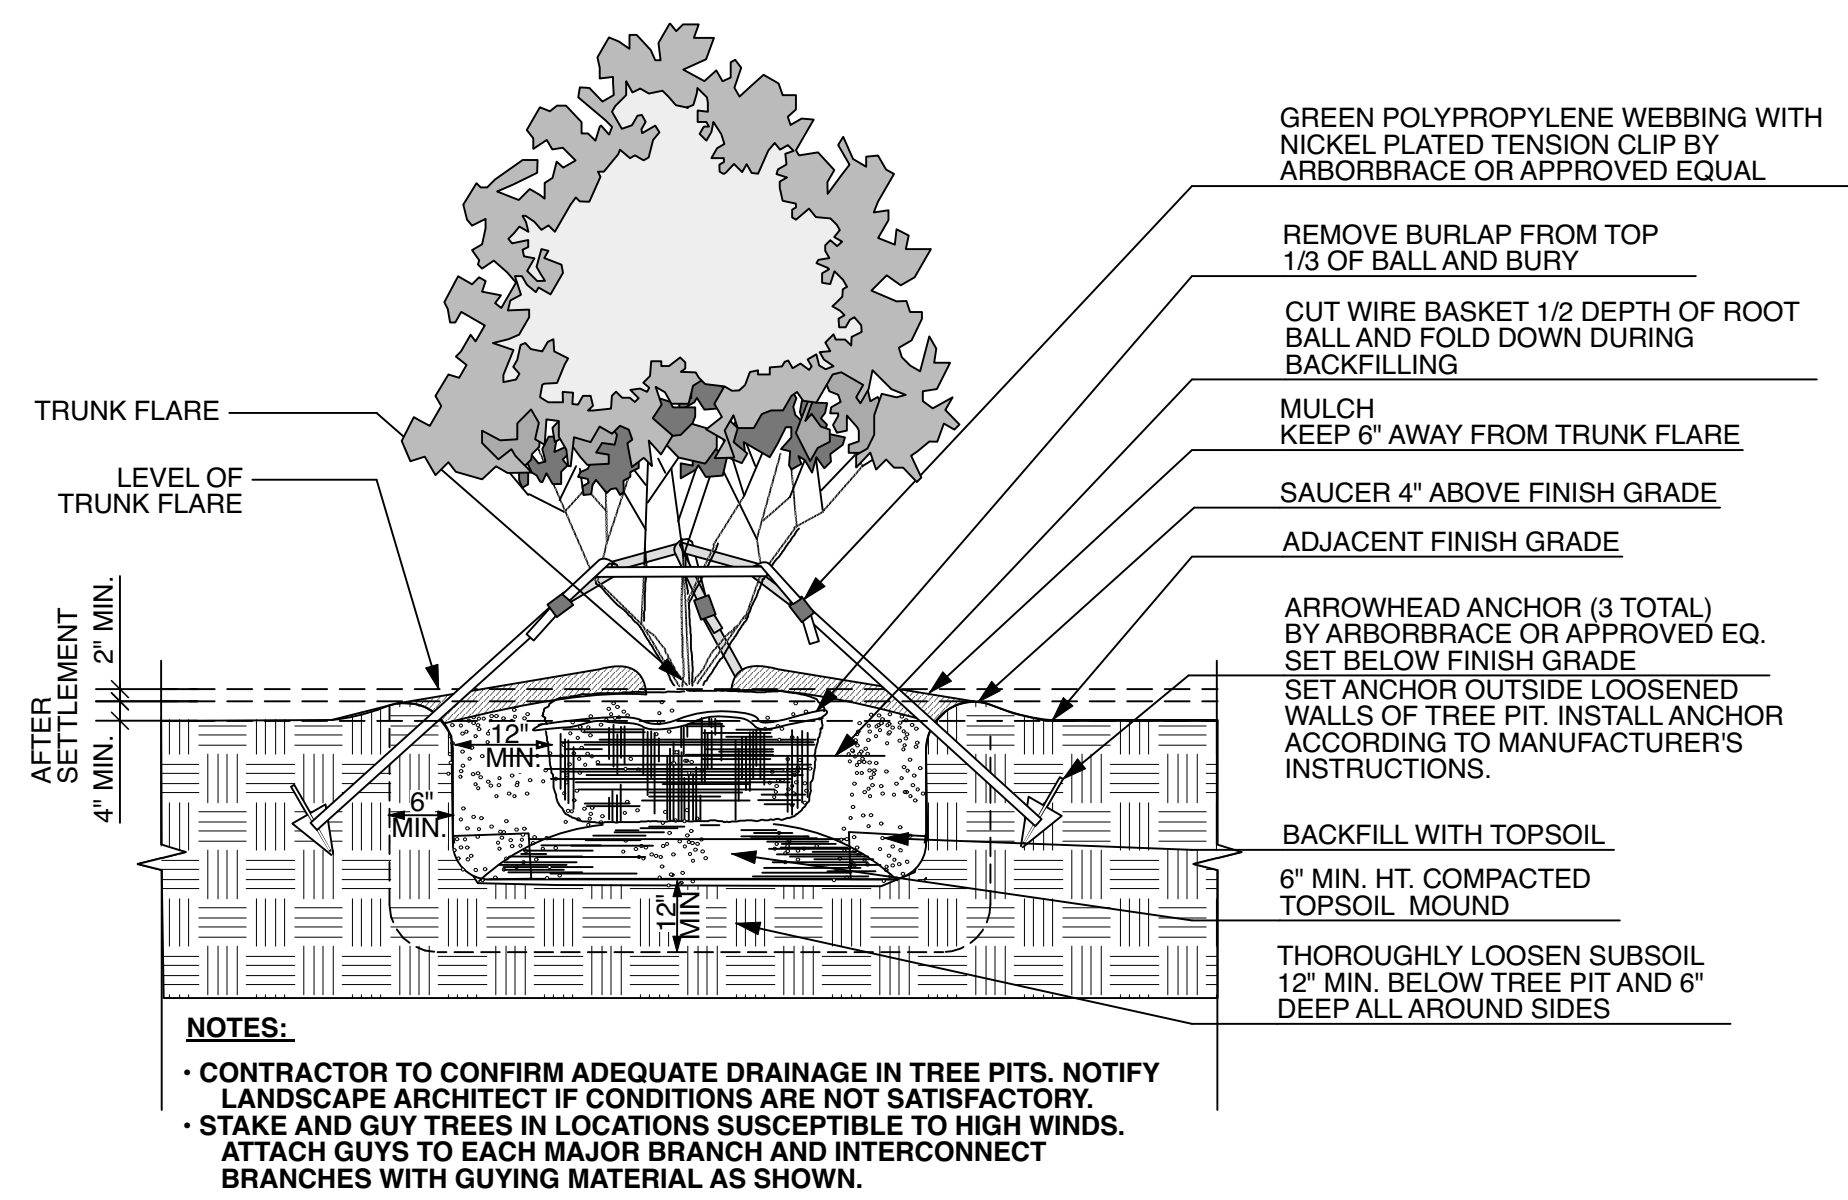


2 MULTI-TRUNK TREE PLANTING DETAIL

NOT TO SCALE

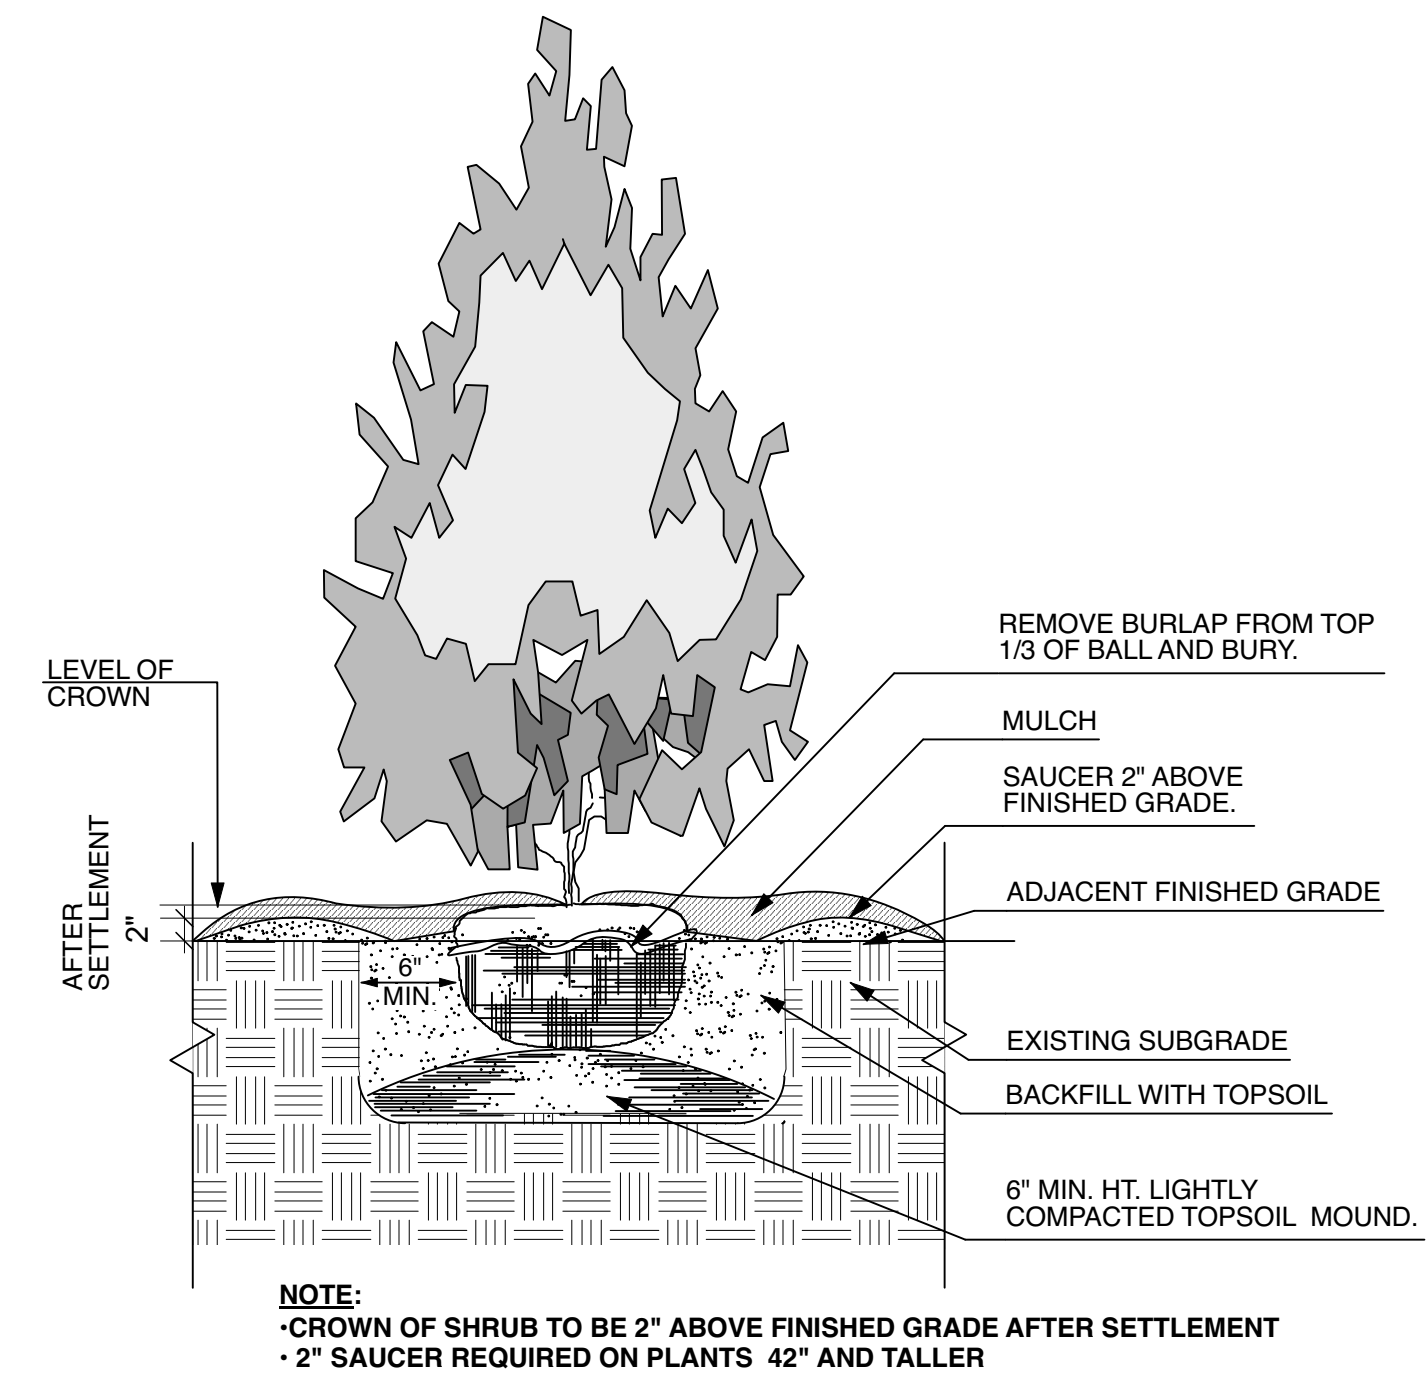


3 B&B SHRUB PLANTING DETAIL

NOT TO SCALE

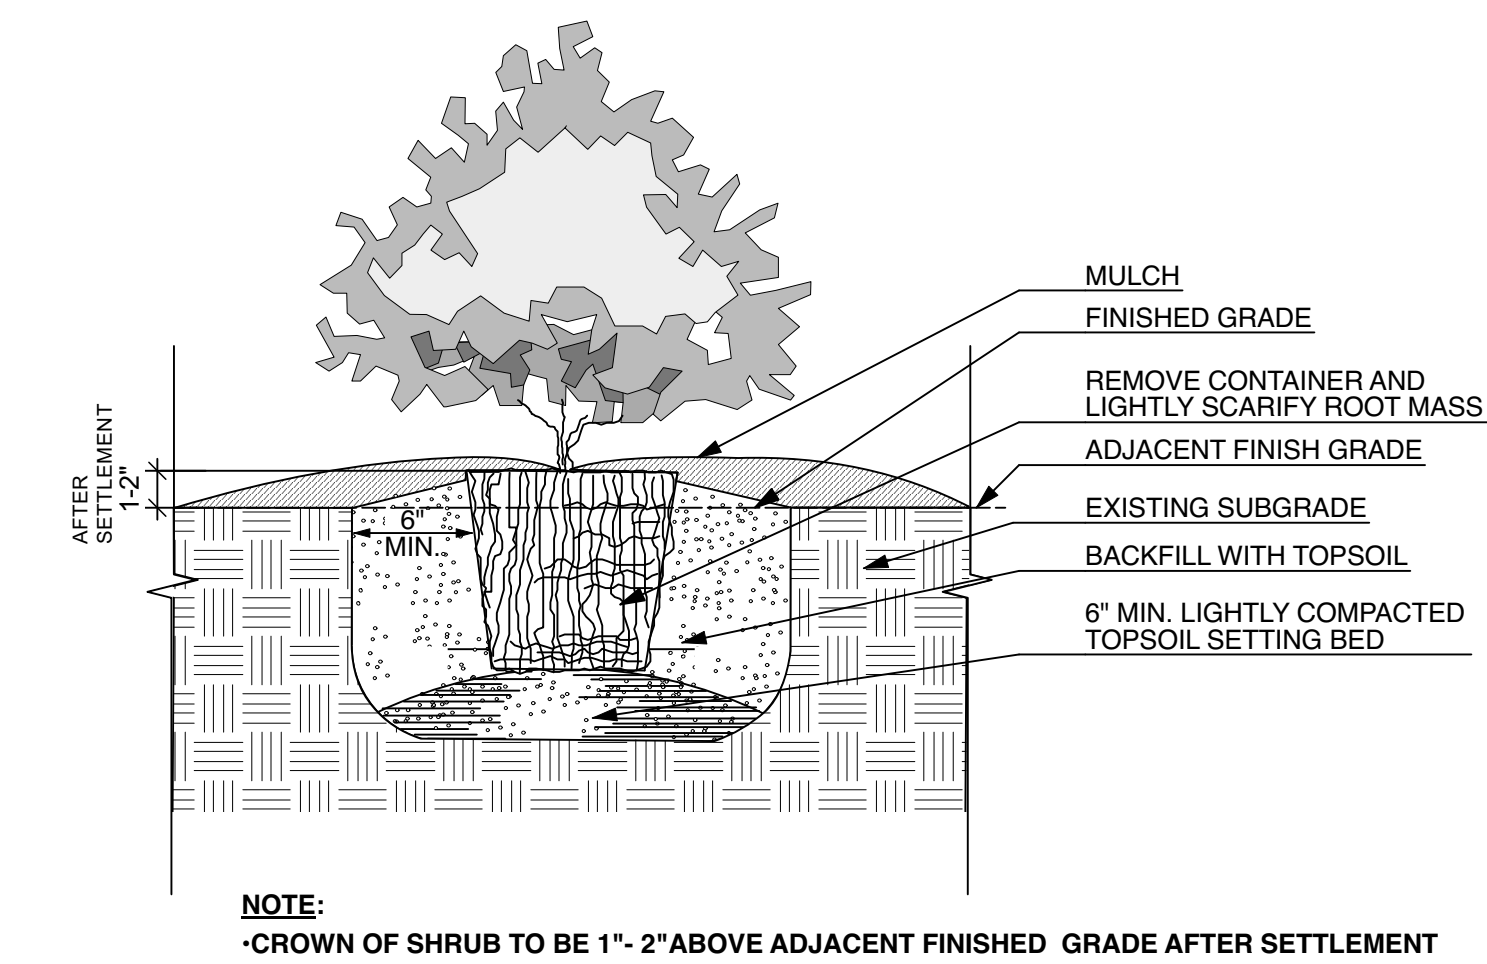


4 CONTAINER SHRUB PLANTING DETAIL

NOT TO SCALE

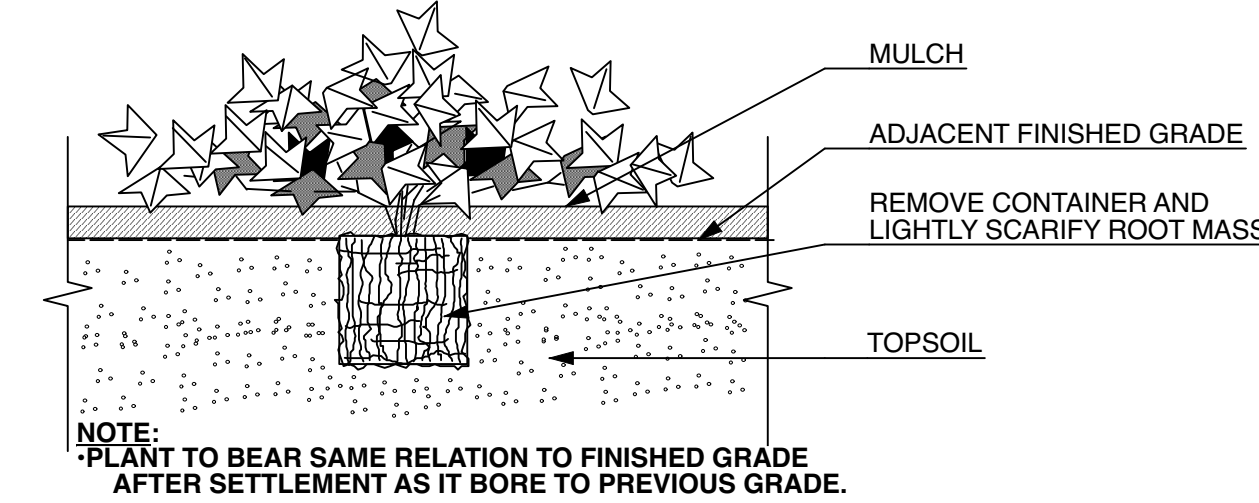


5 GROUNDCOVER PLANTING DETAIL

NOT TO SCALE

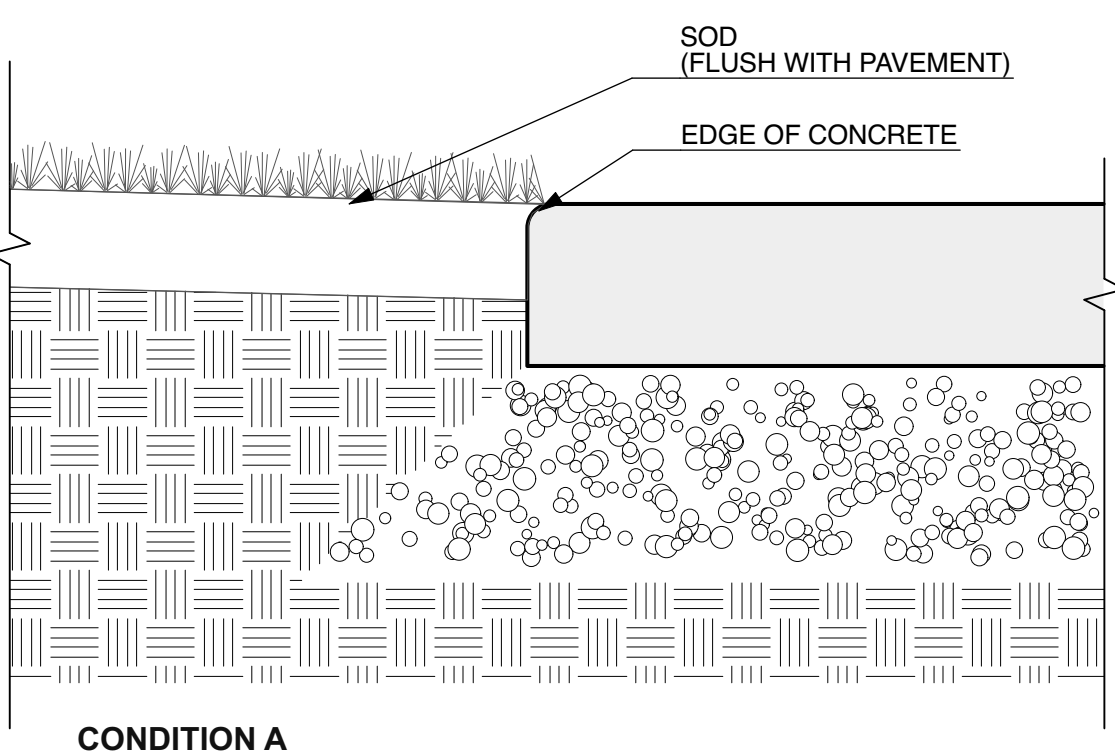


CONDITION A

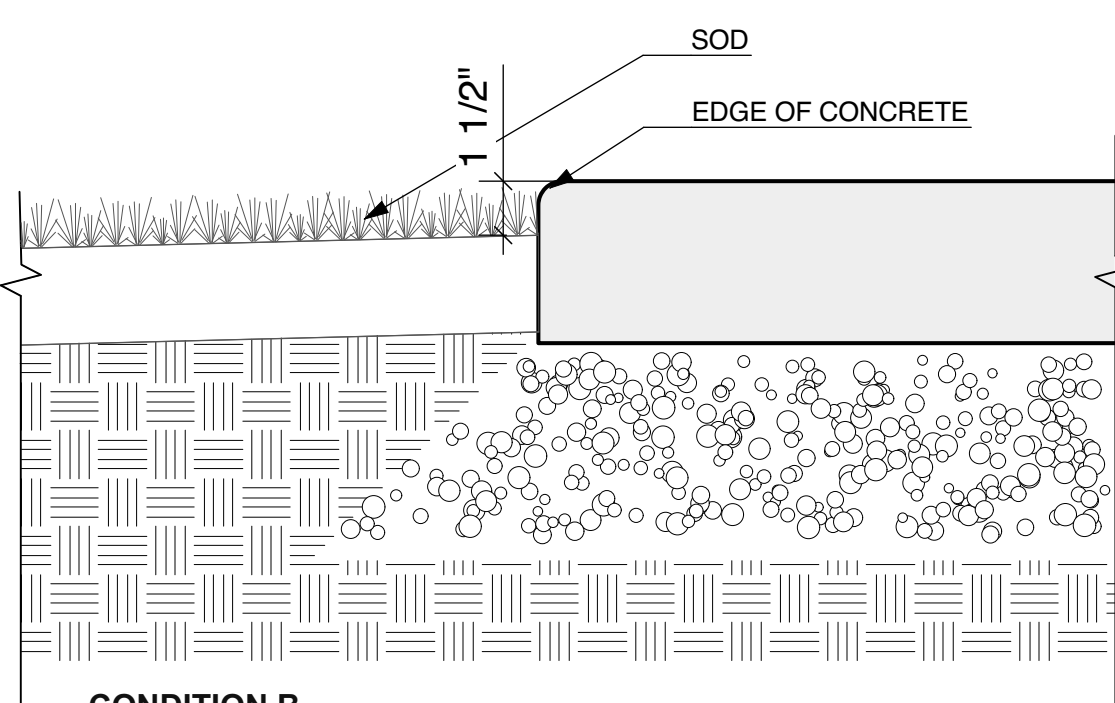

CONDITION B


7 SOD AT PAVING EDGE

NOT TO SCALE

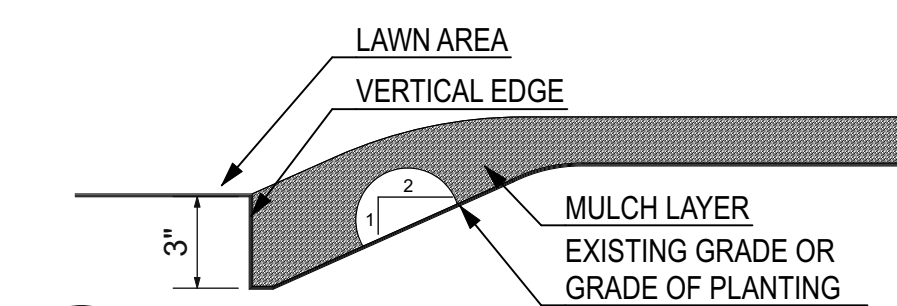


8 TRENCHED EDGE

NOT TO SCALE

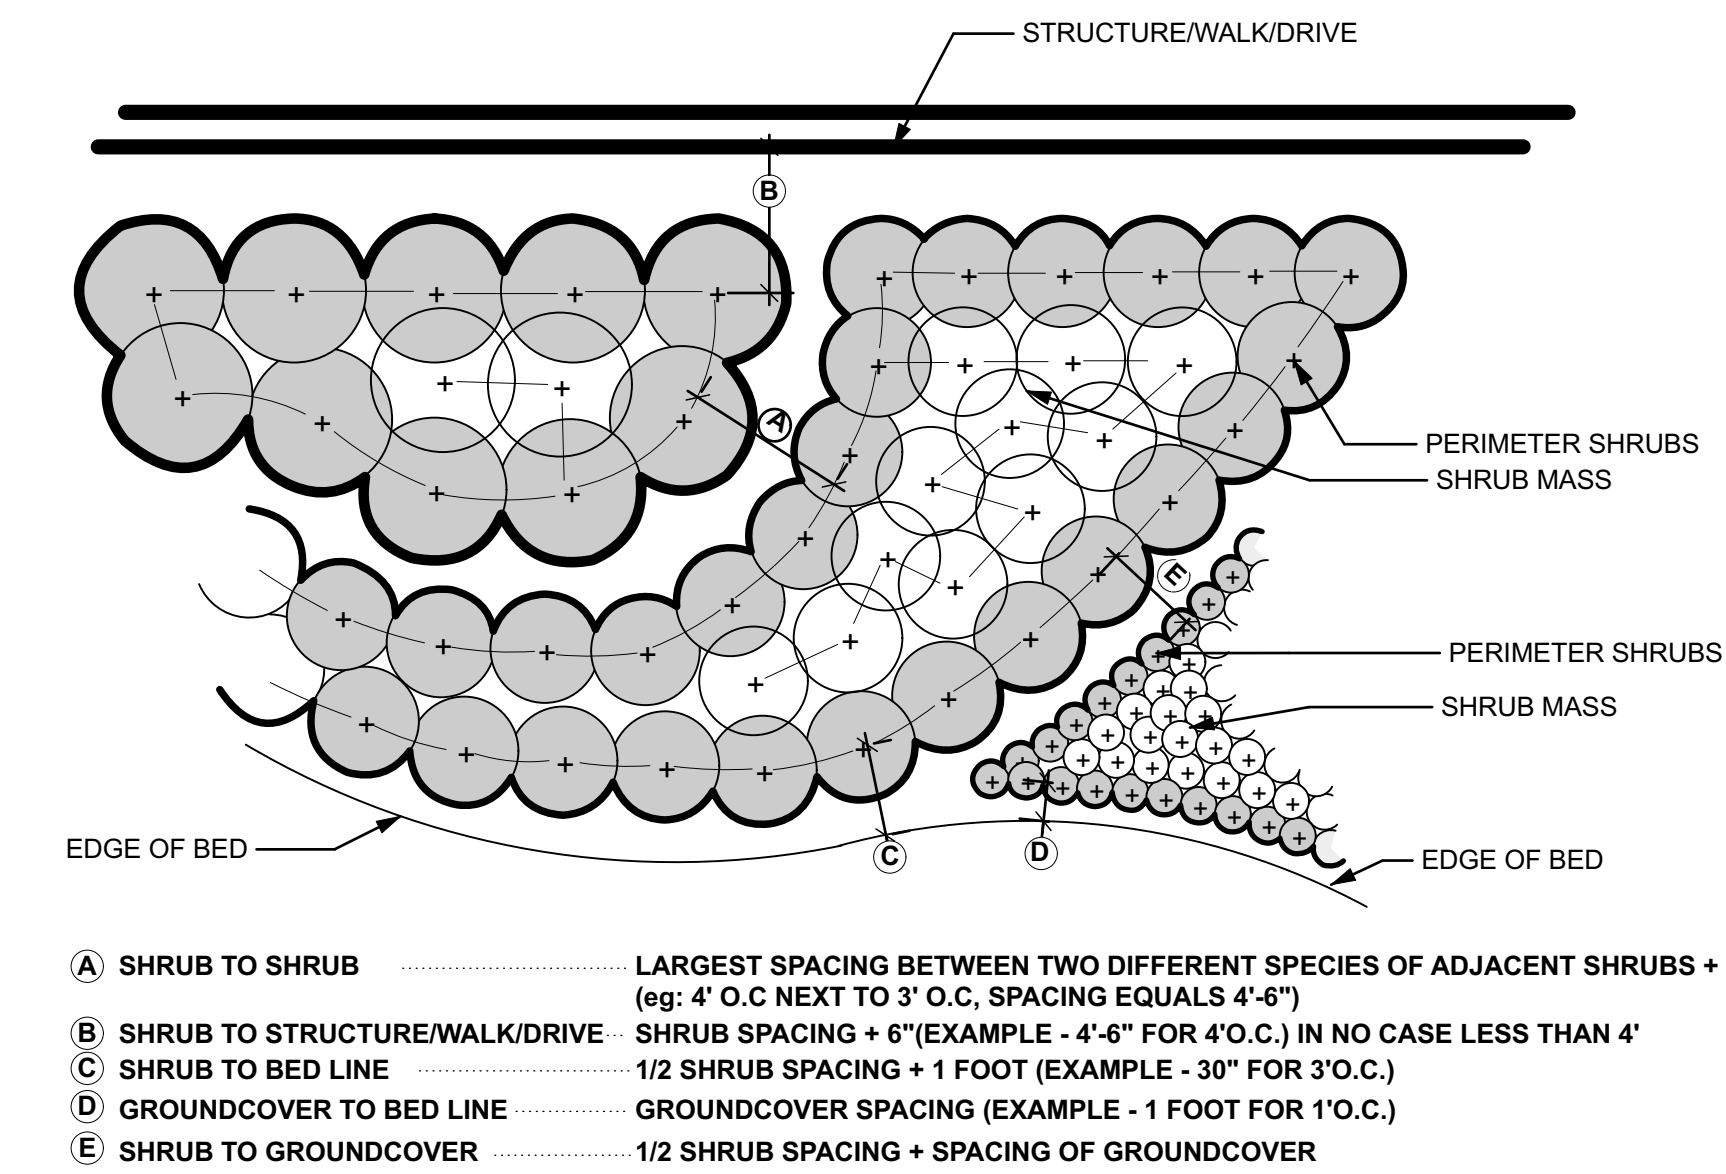


6 PLANT LAYOUT FOR FREE FORM MASSES





NOT TO SCALE

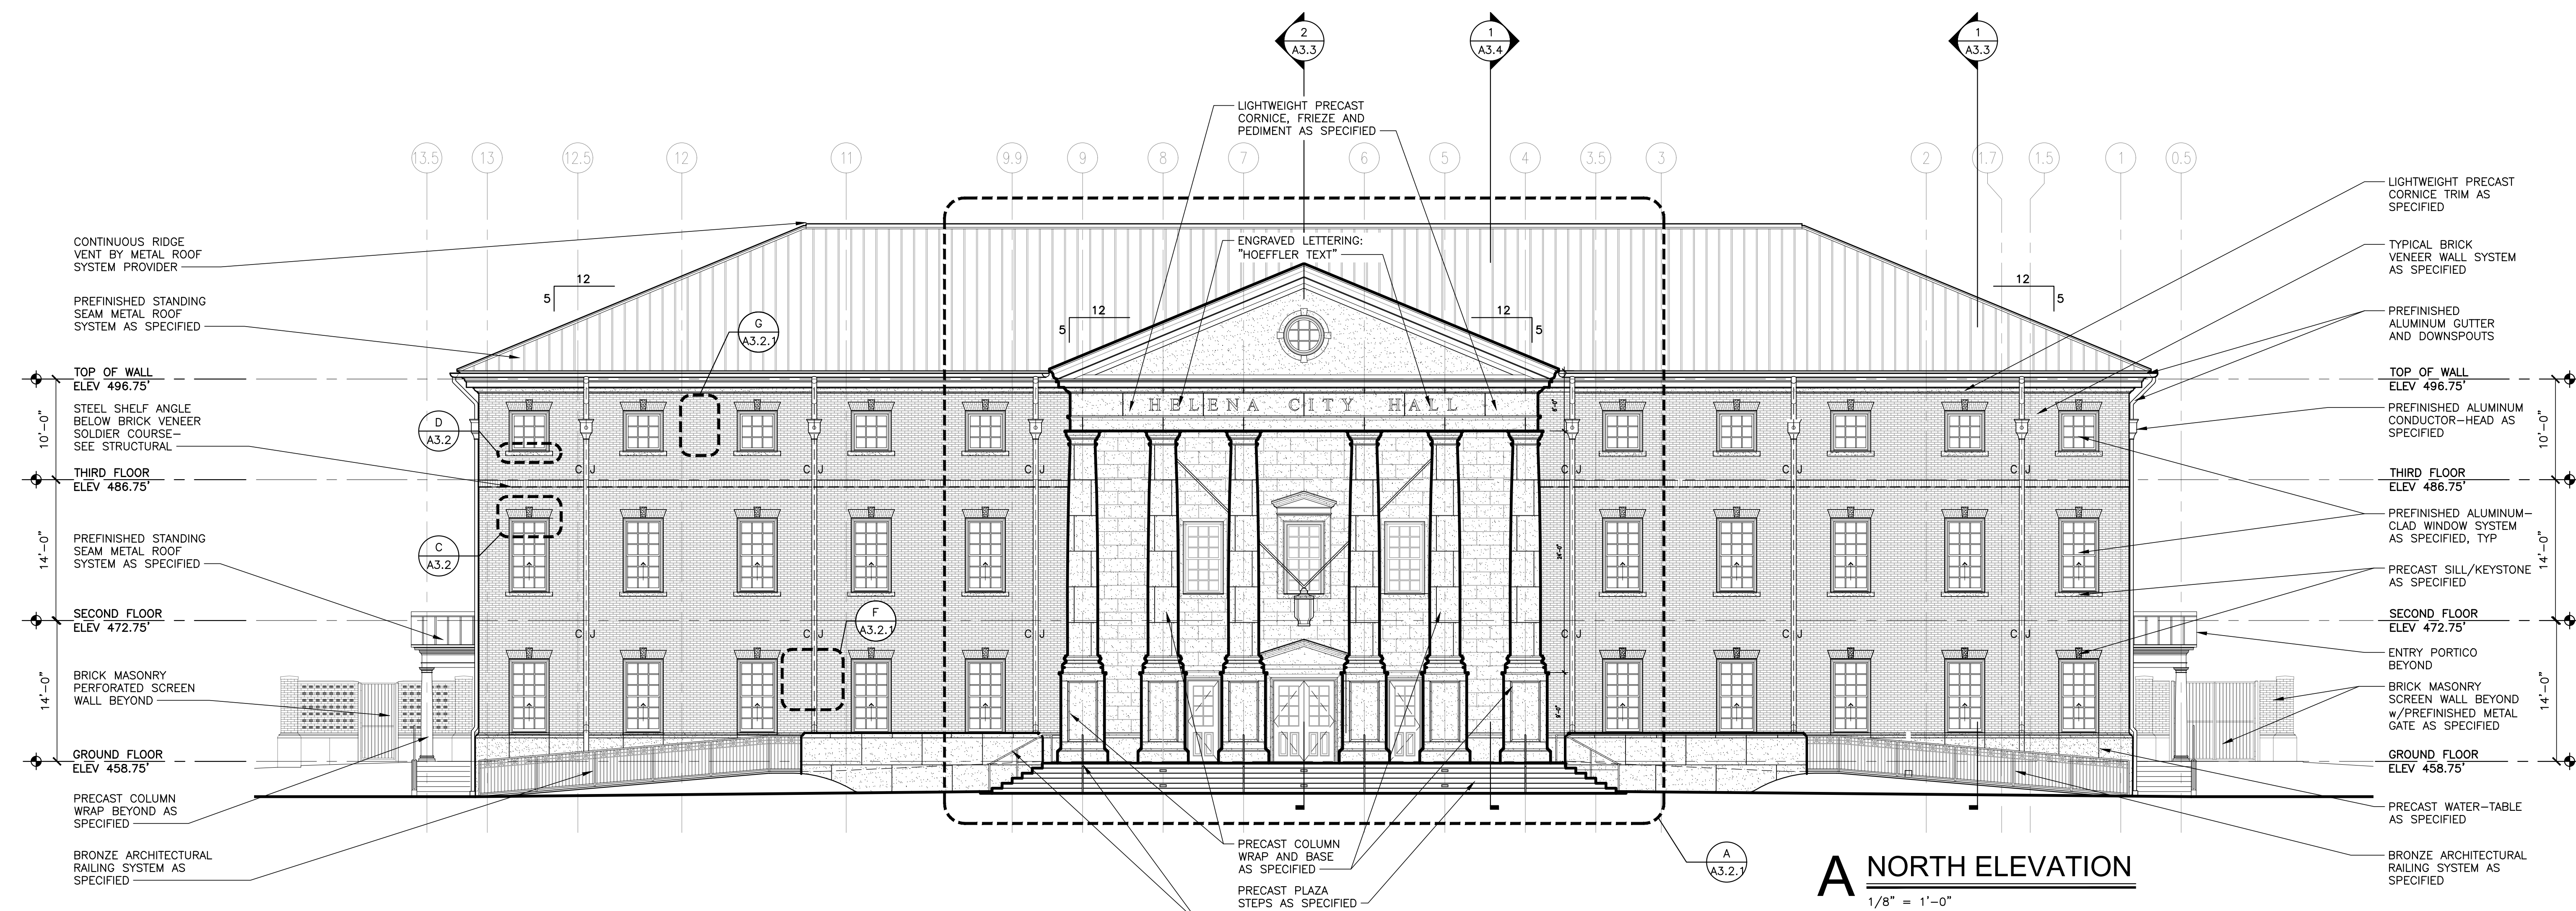


A NORTH ELEVATION
1/8" = 1'-0"

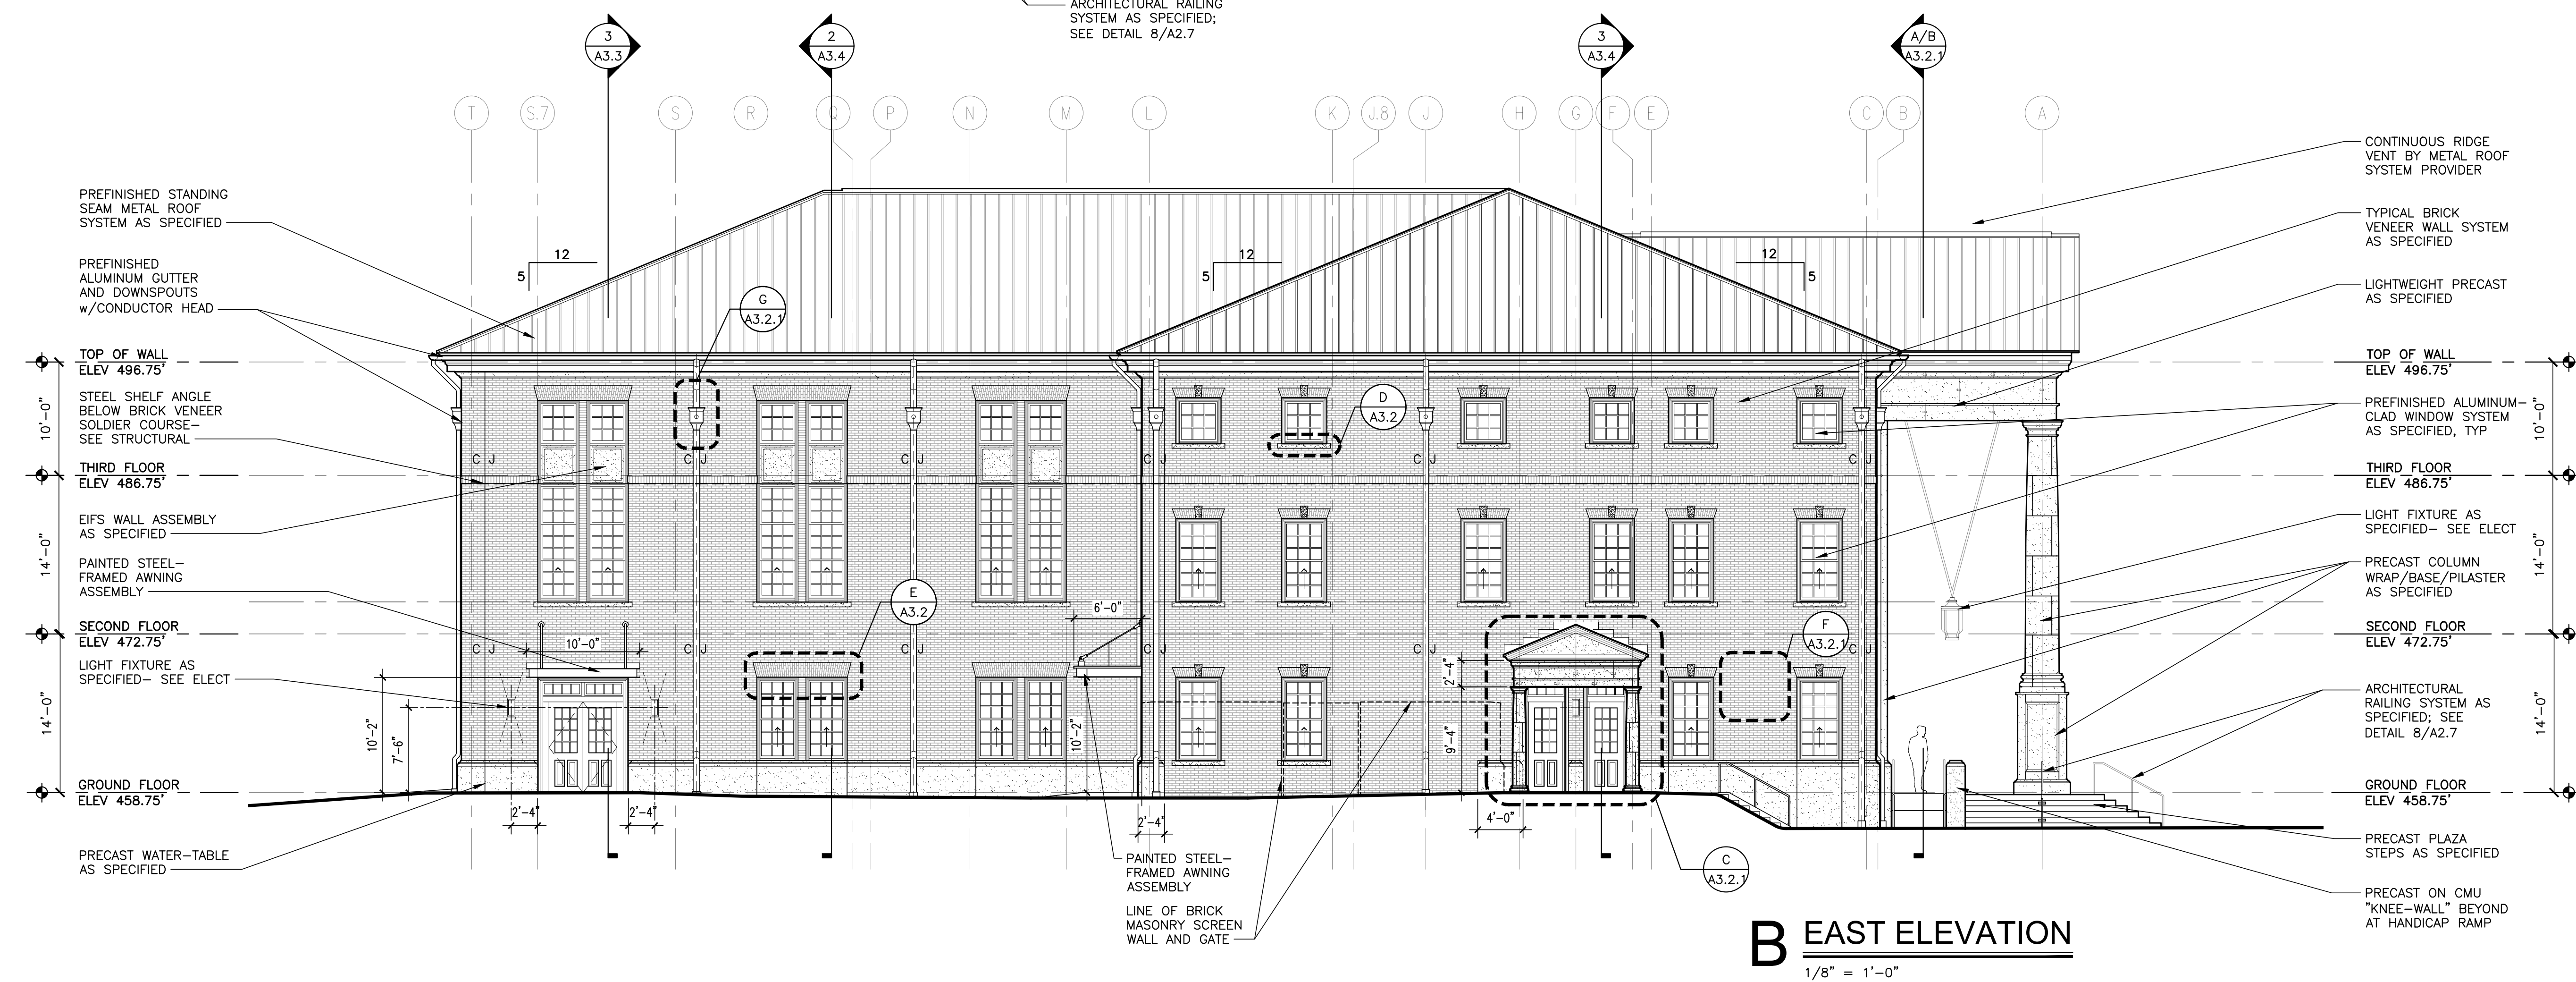


B EAST ELEVATION
1/8" = 1'-0"

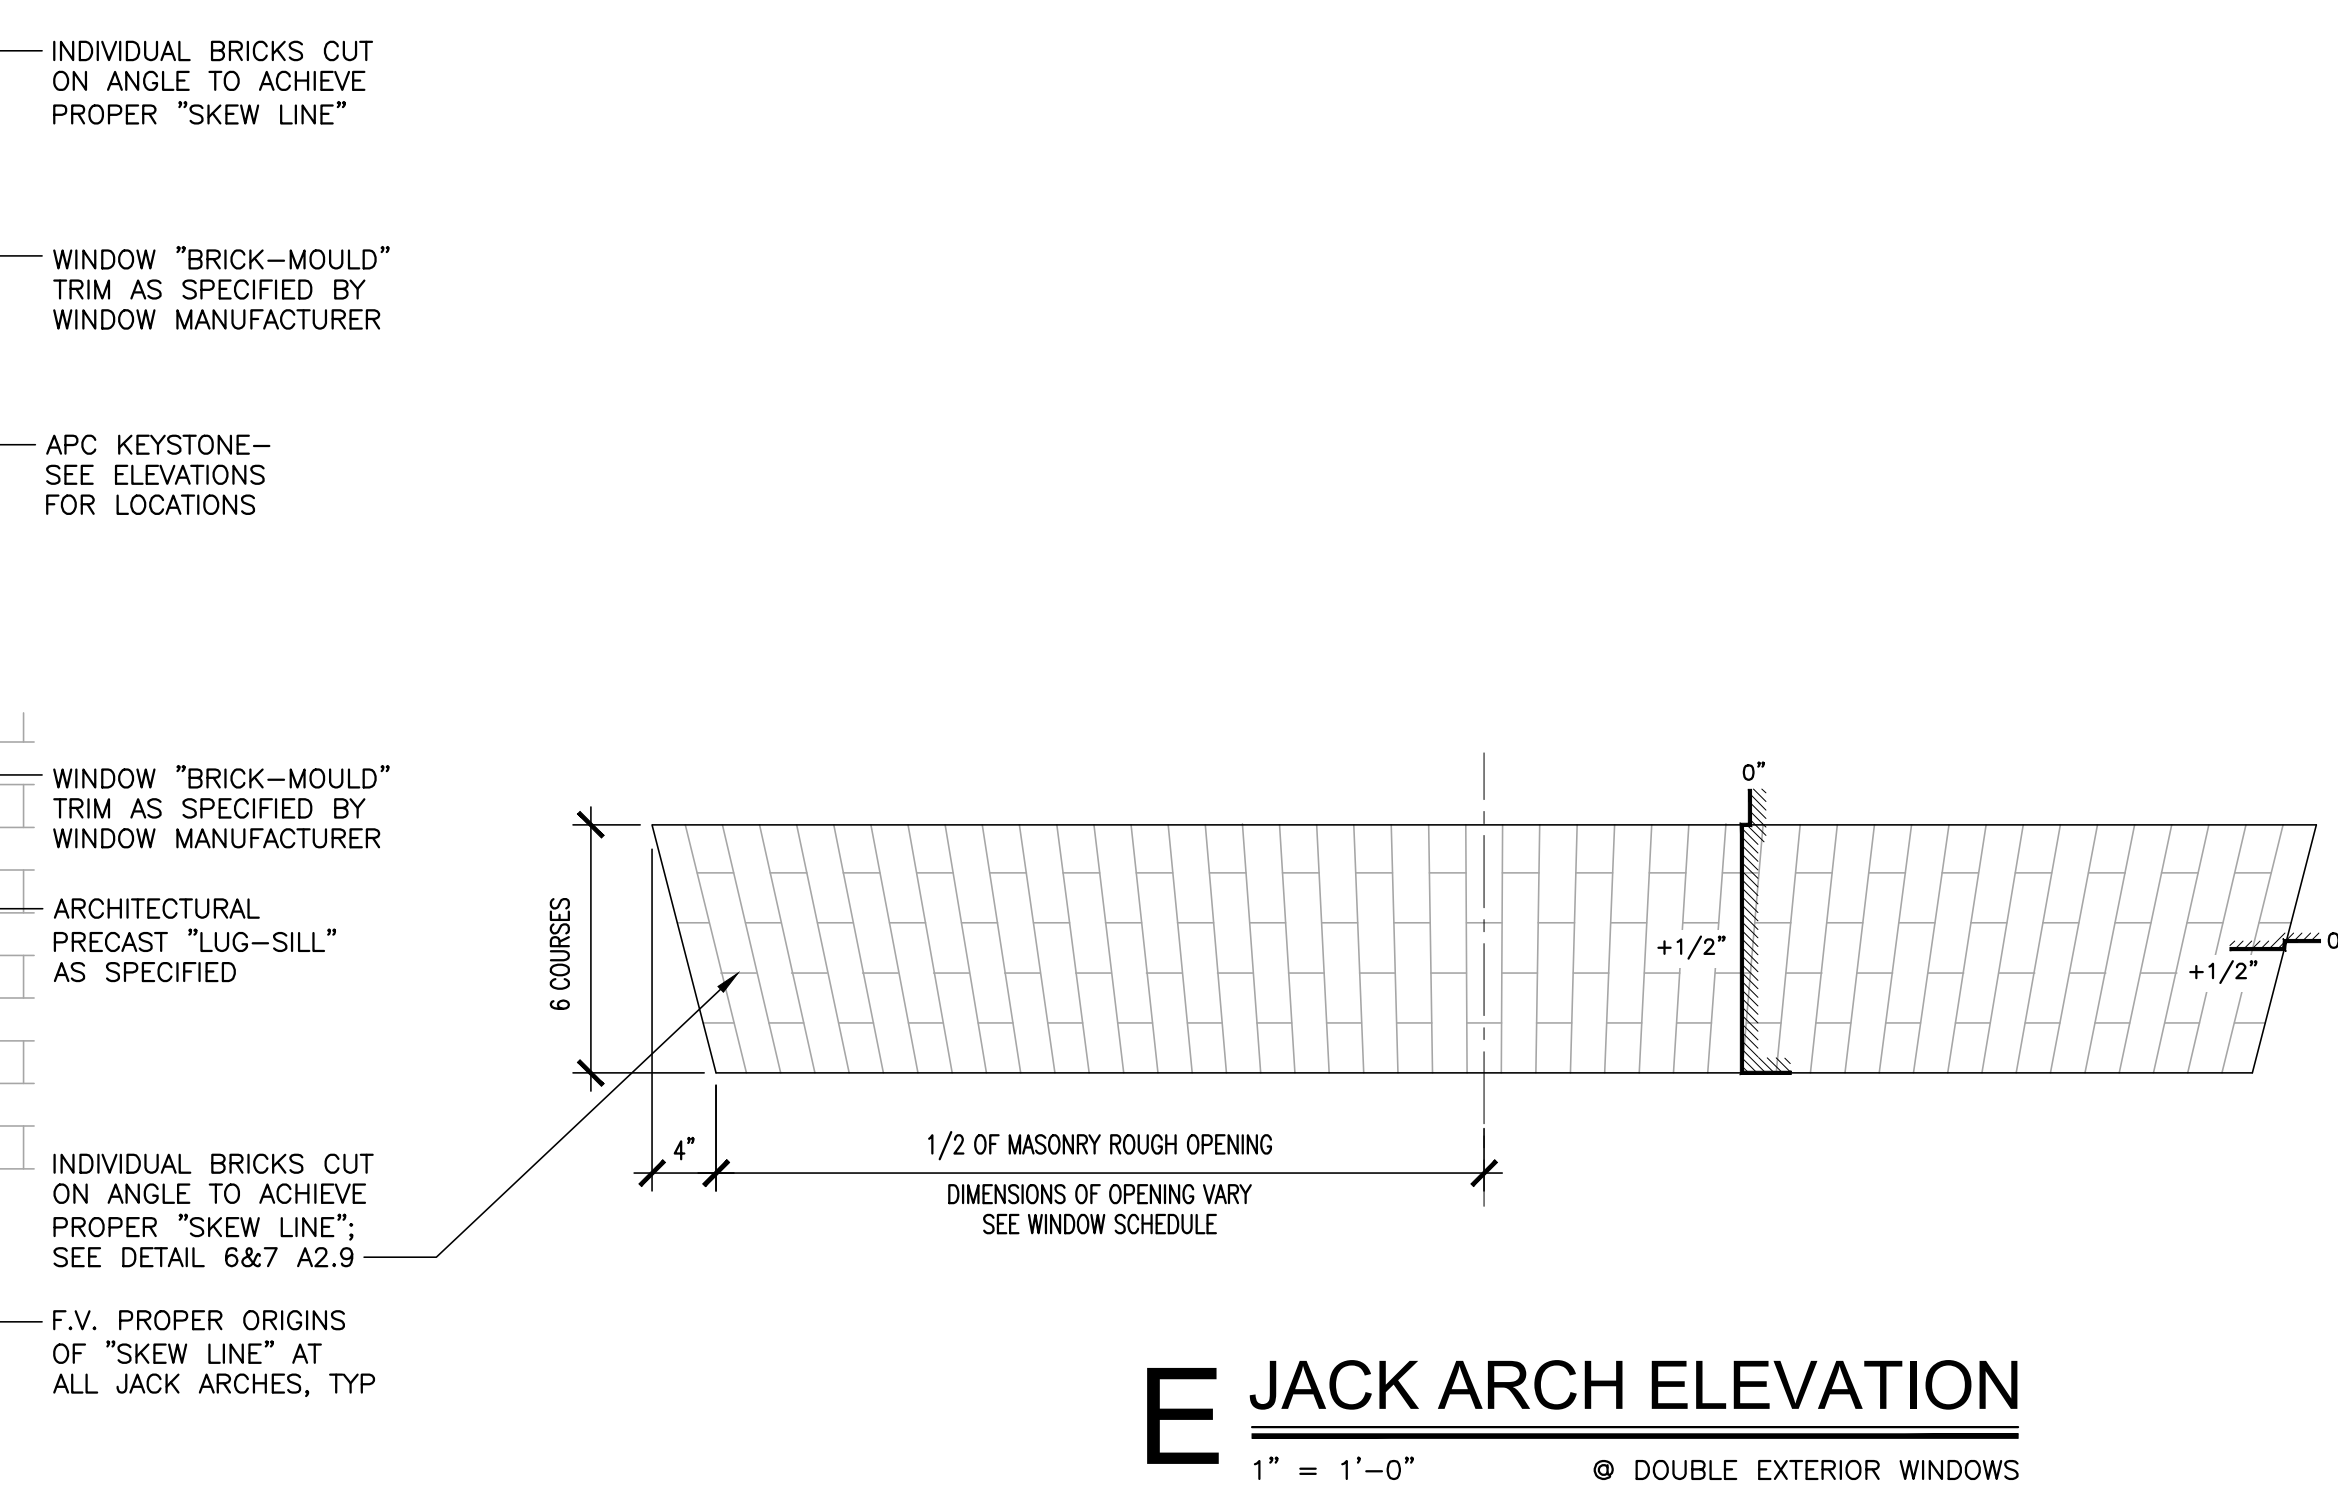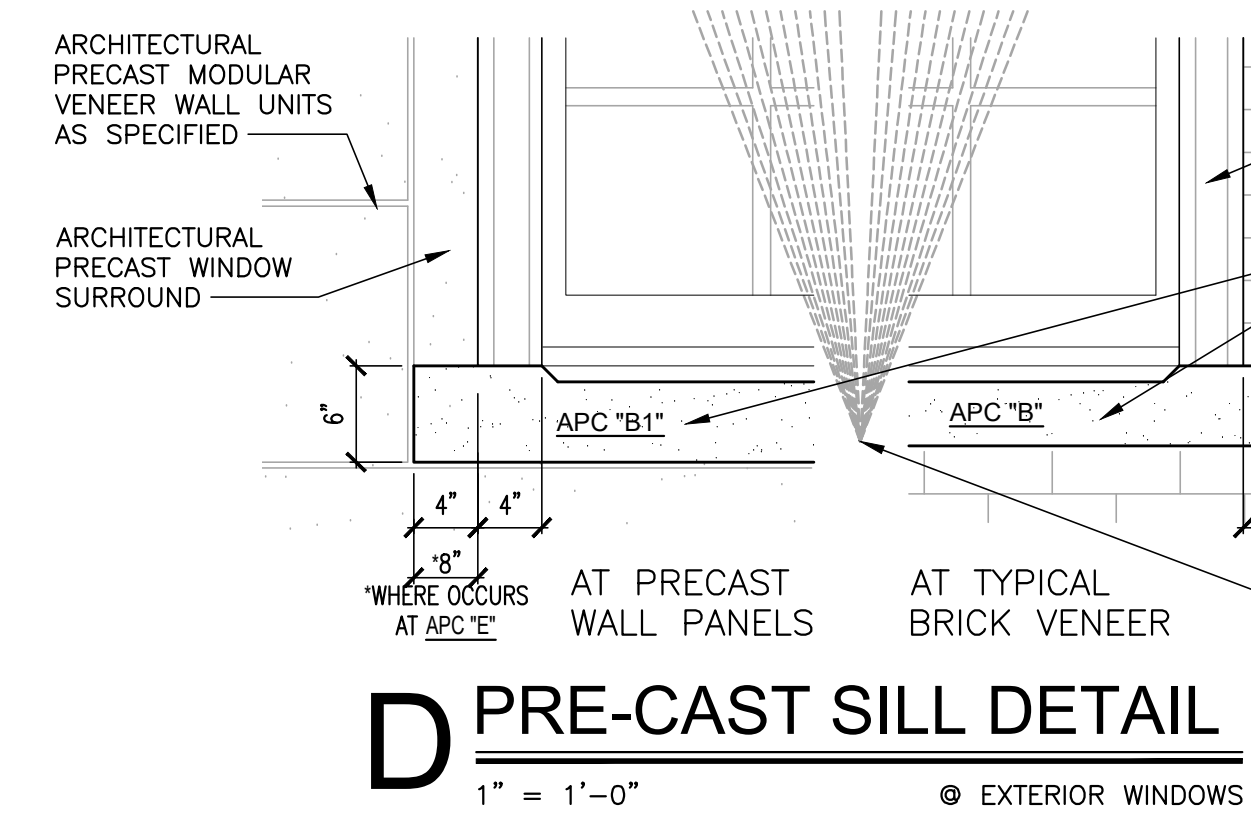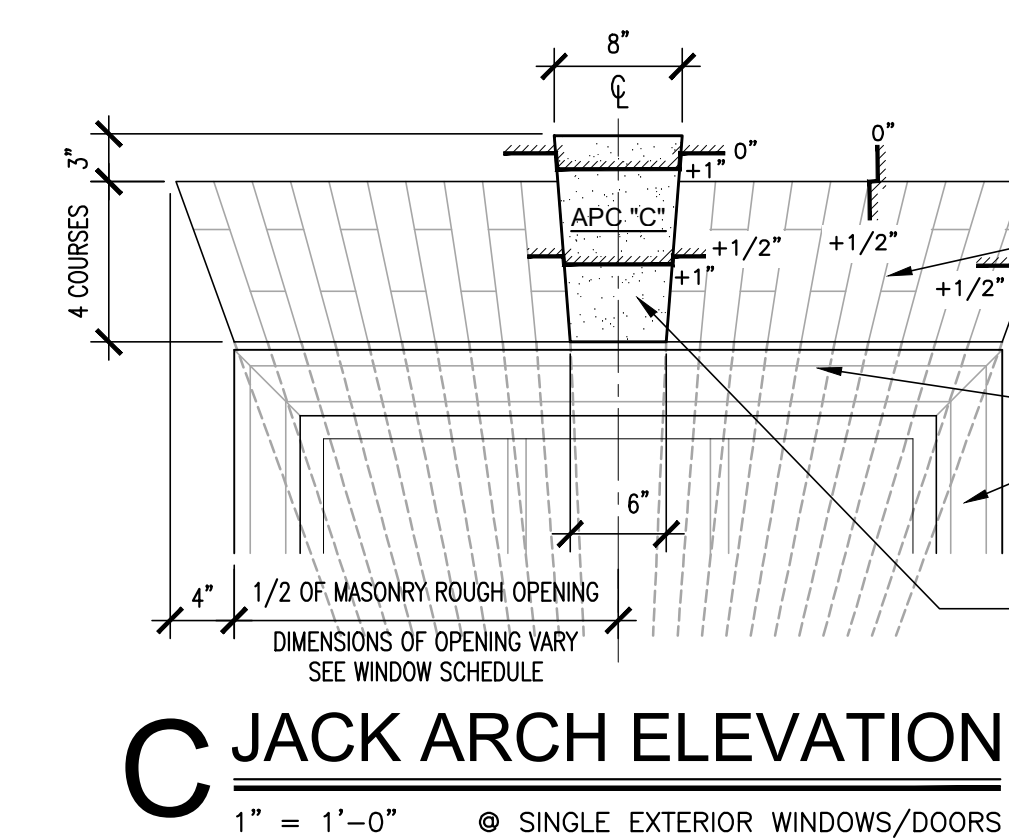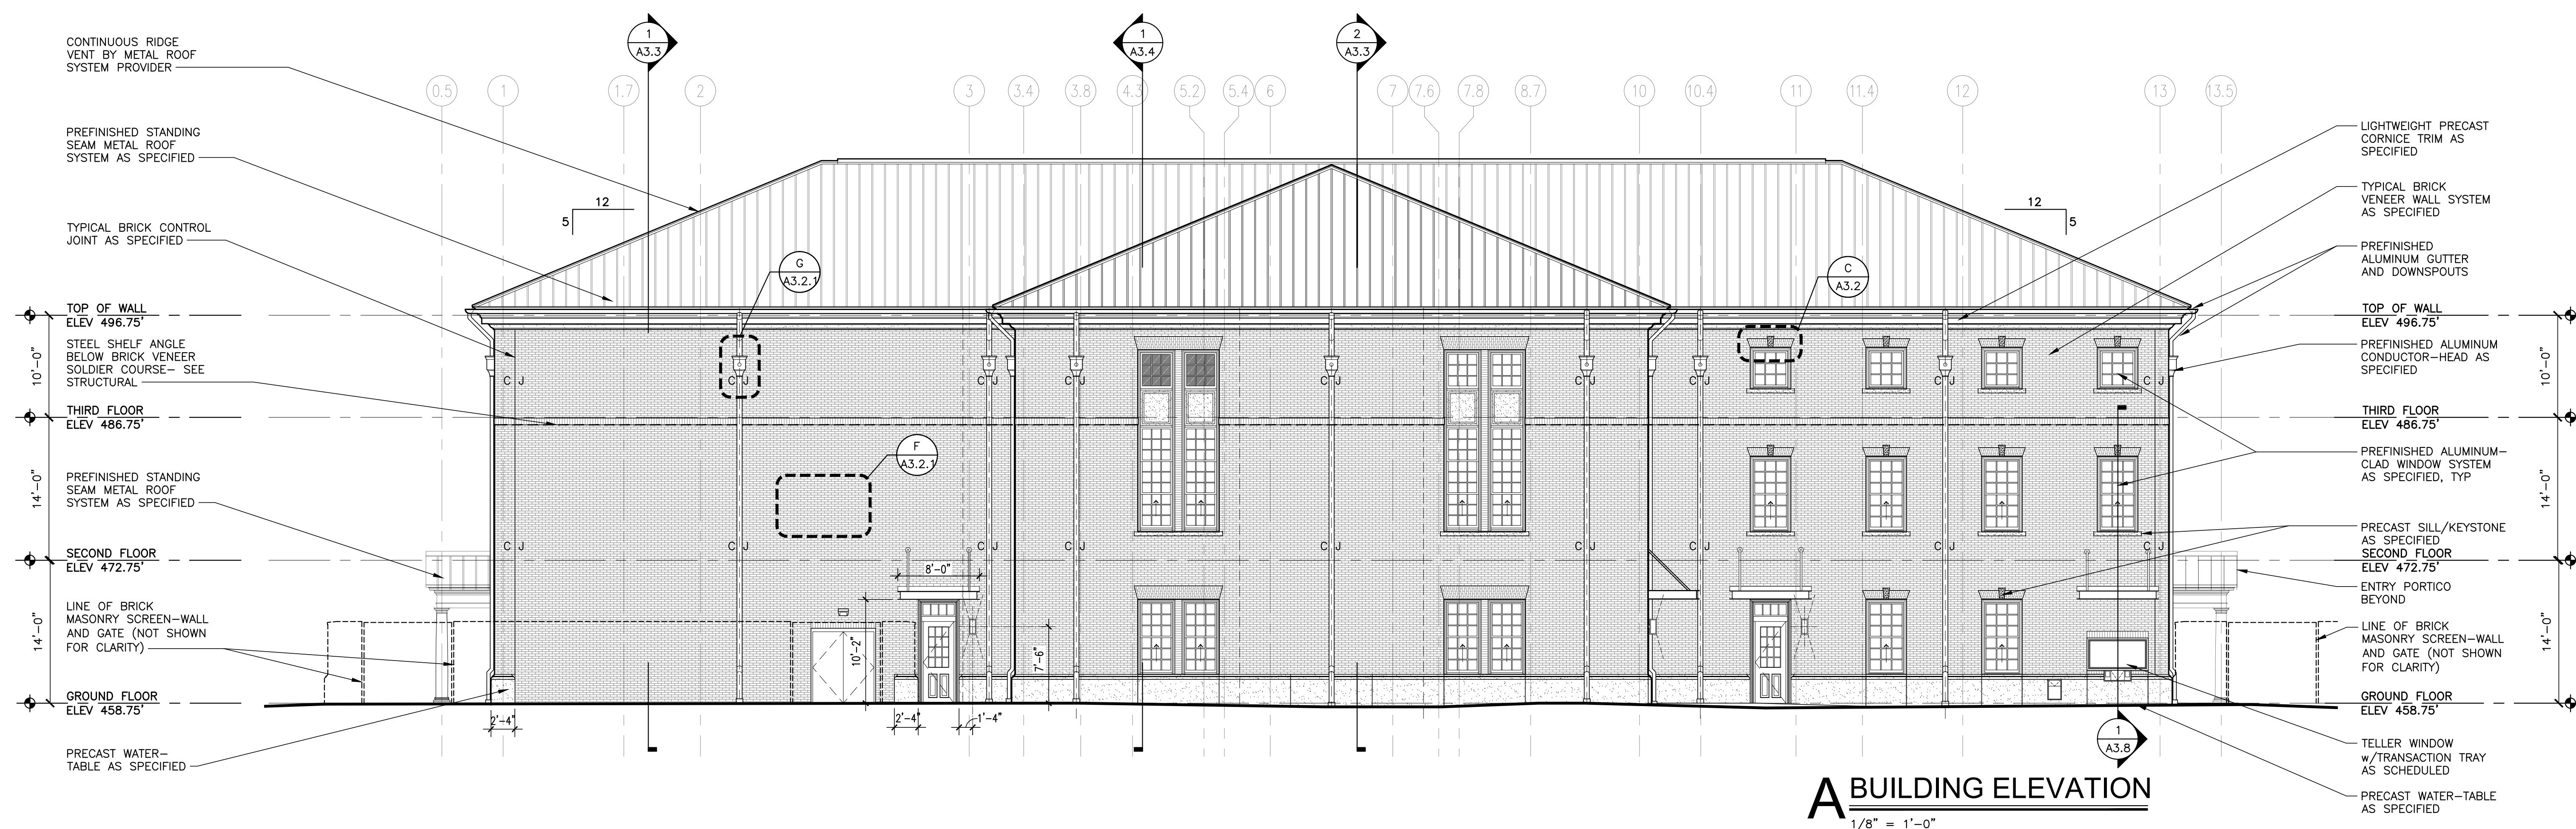


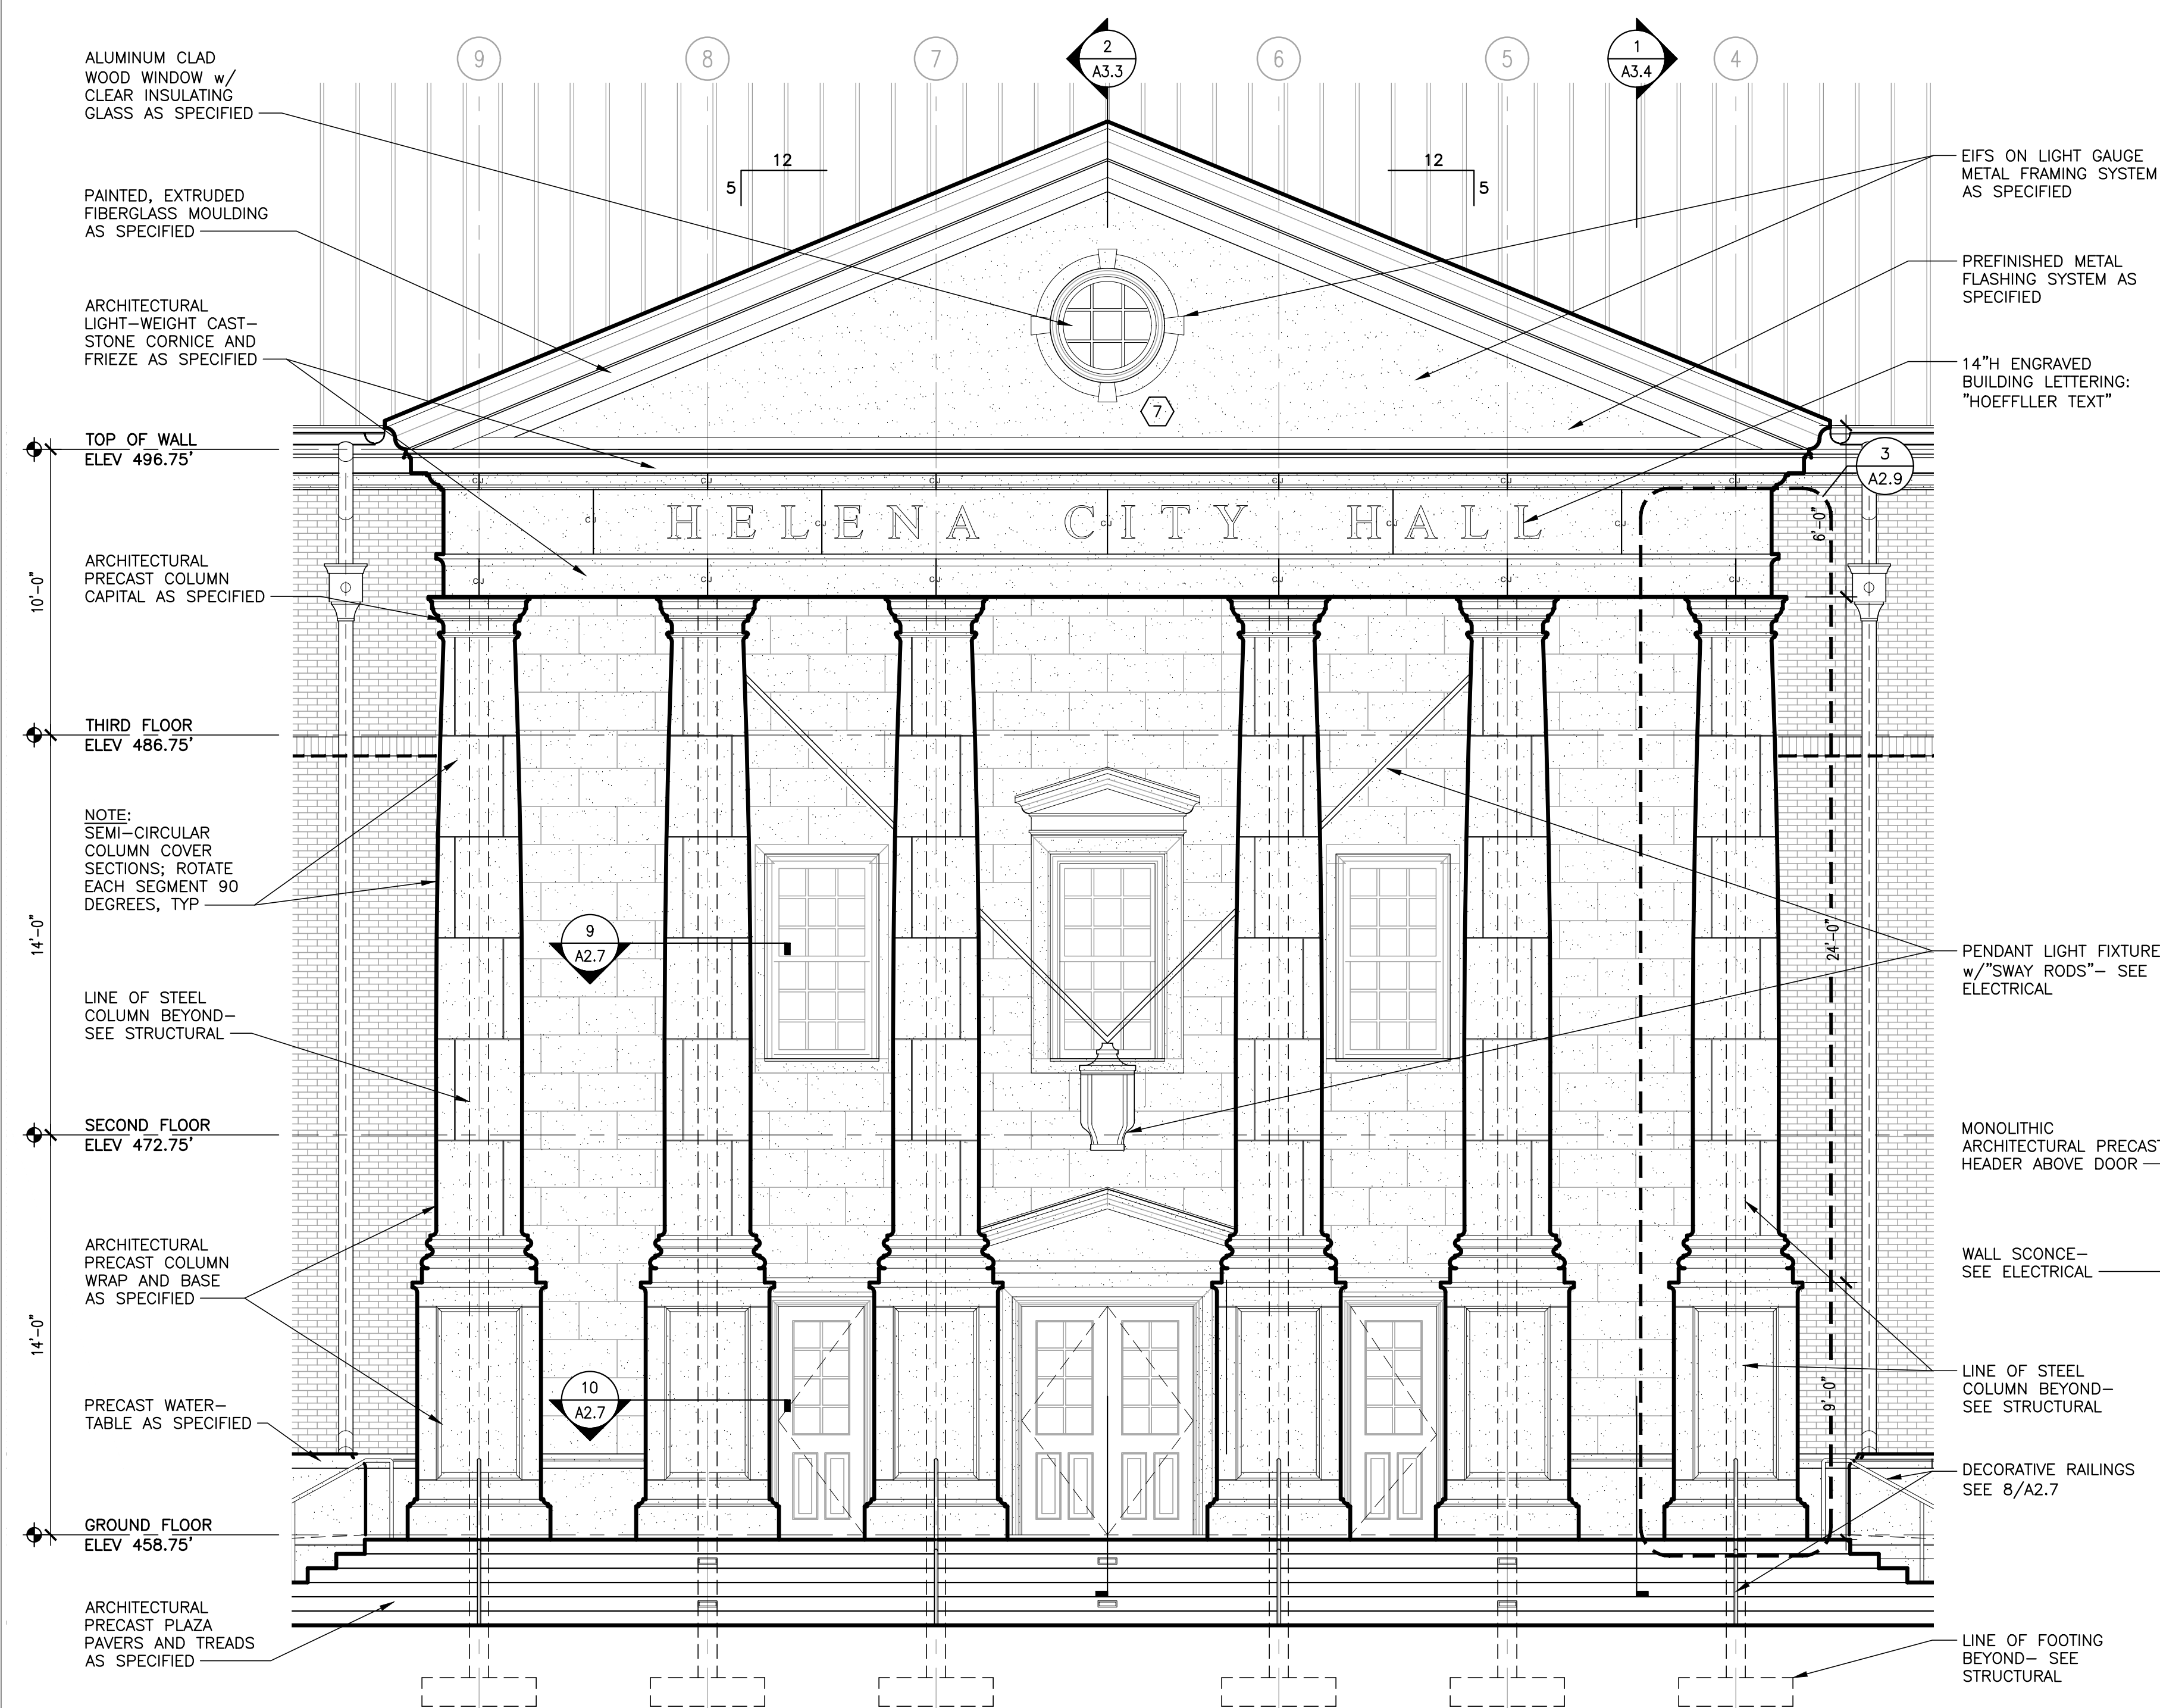


A NORTH PORTICO ELEVATION
1/4" = 1'-0"

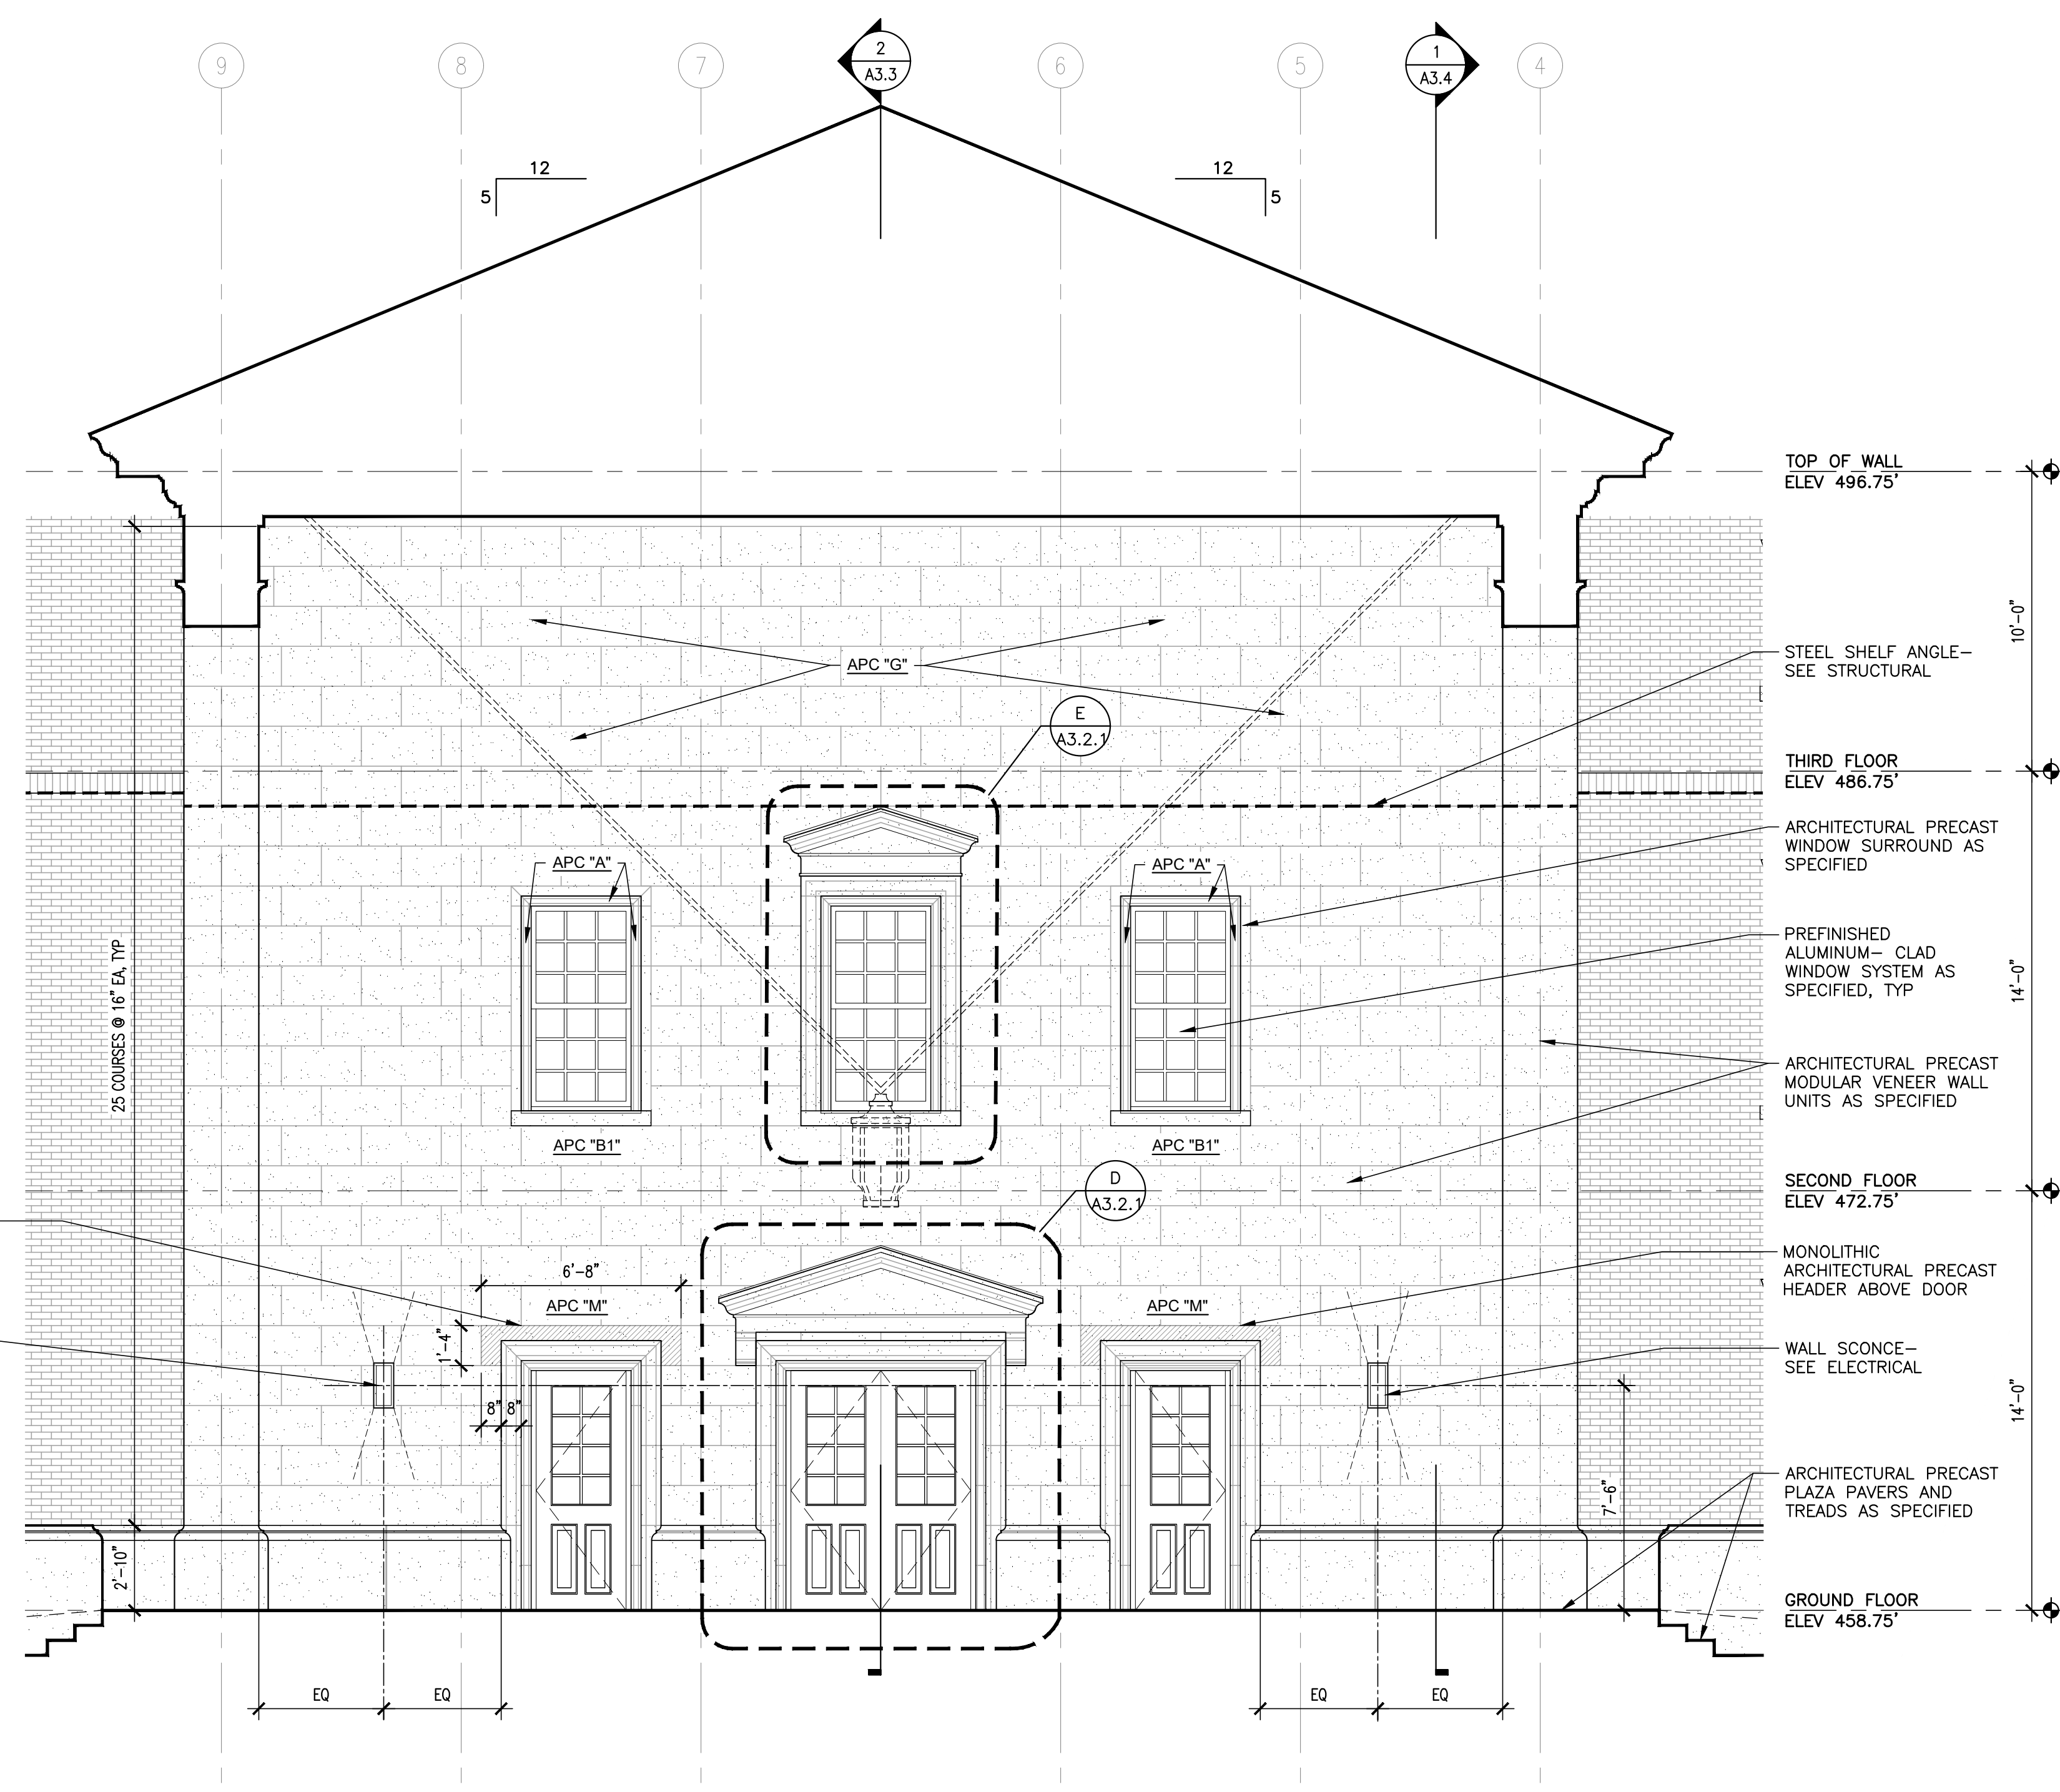


B NORTH PORTICO ELEVATION BEYOND
1/4" = 1'-0"

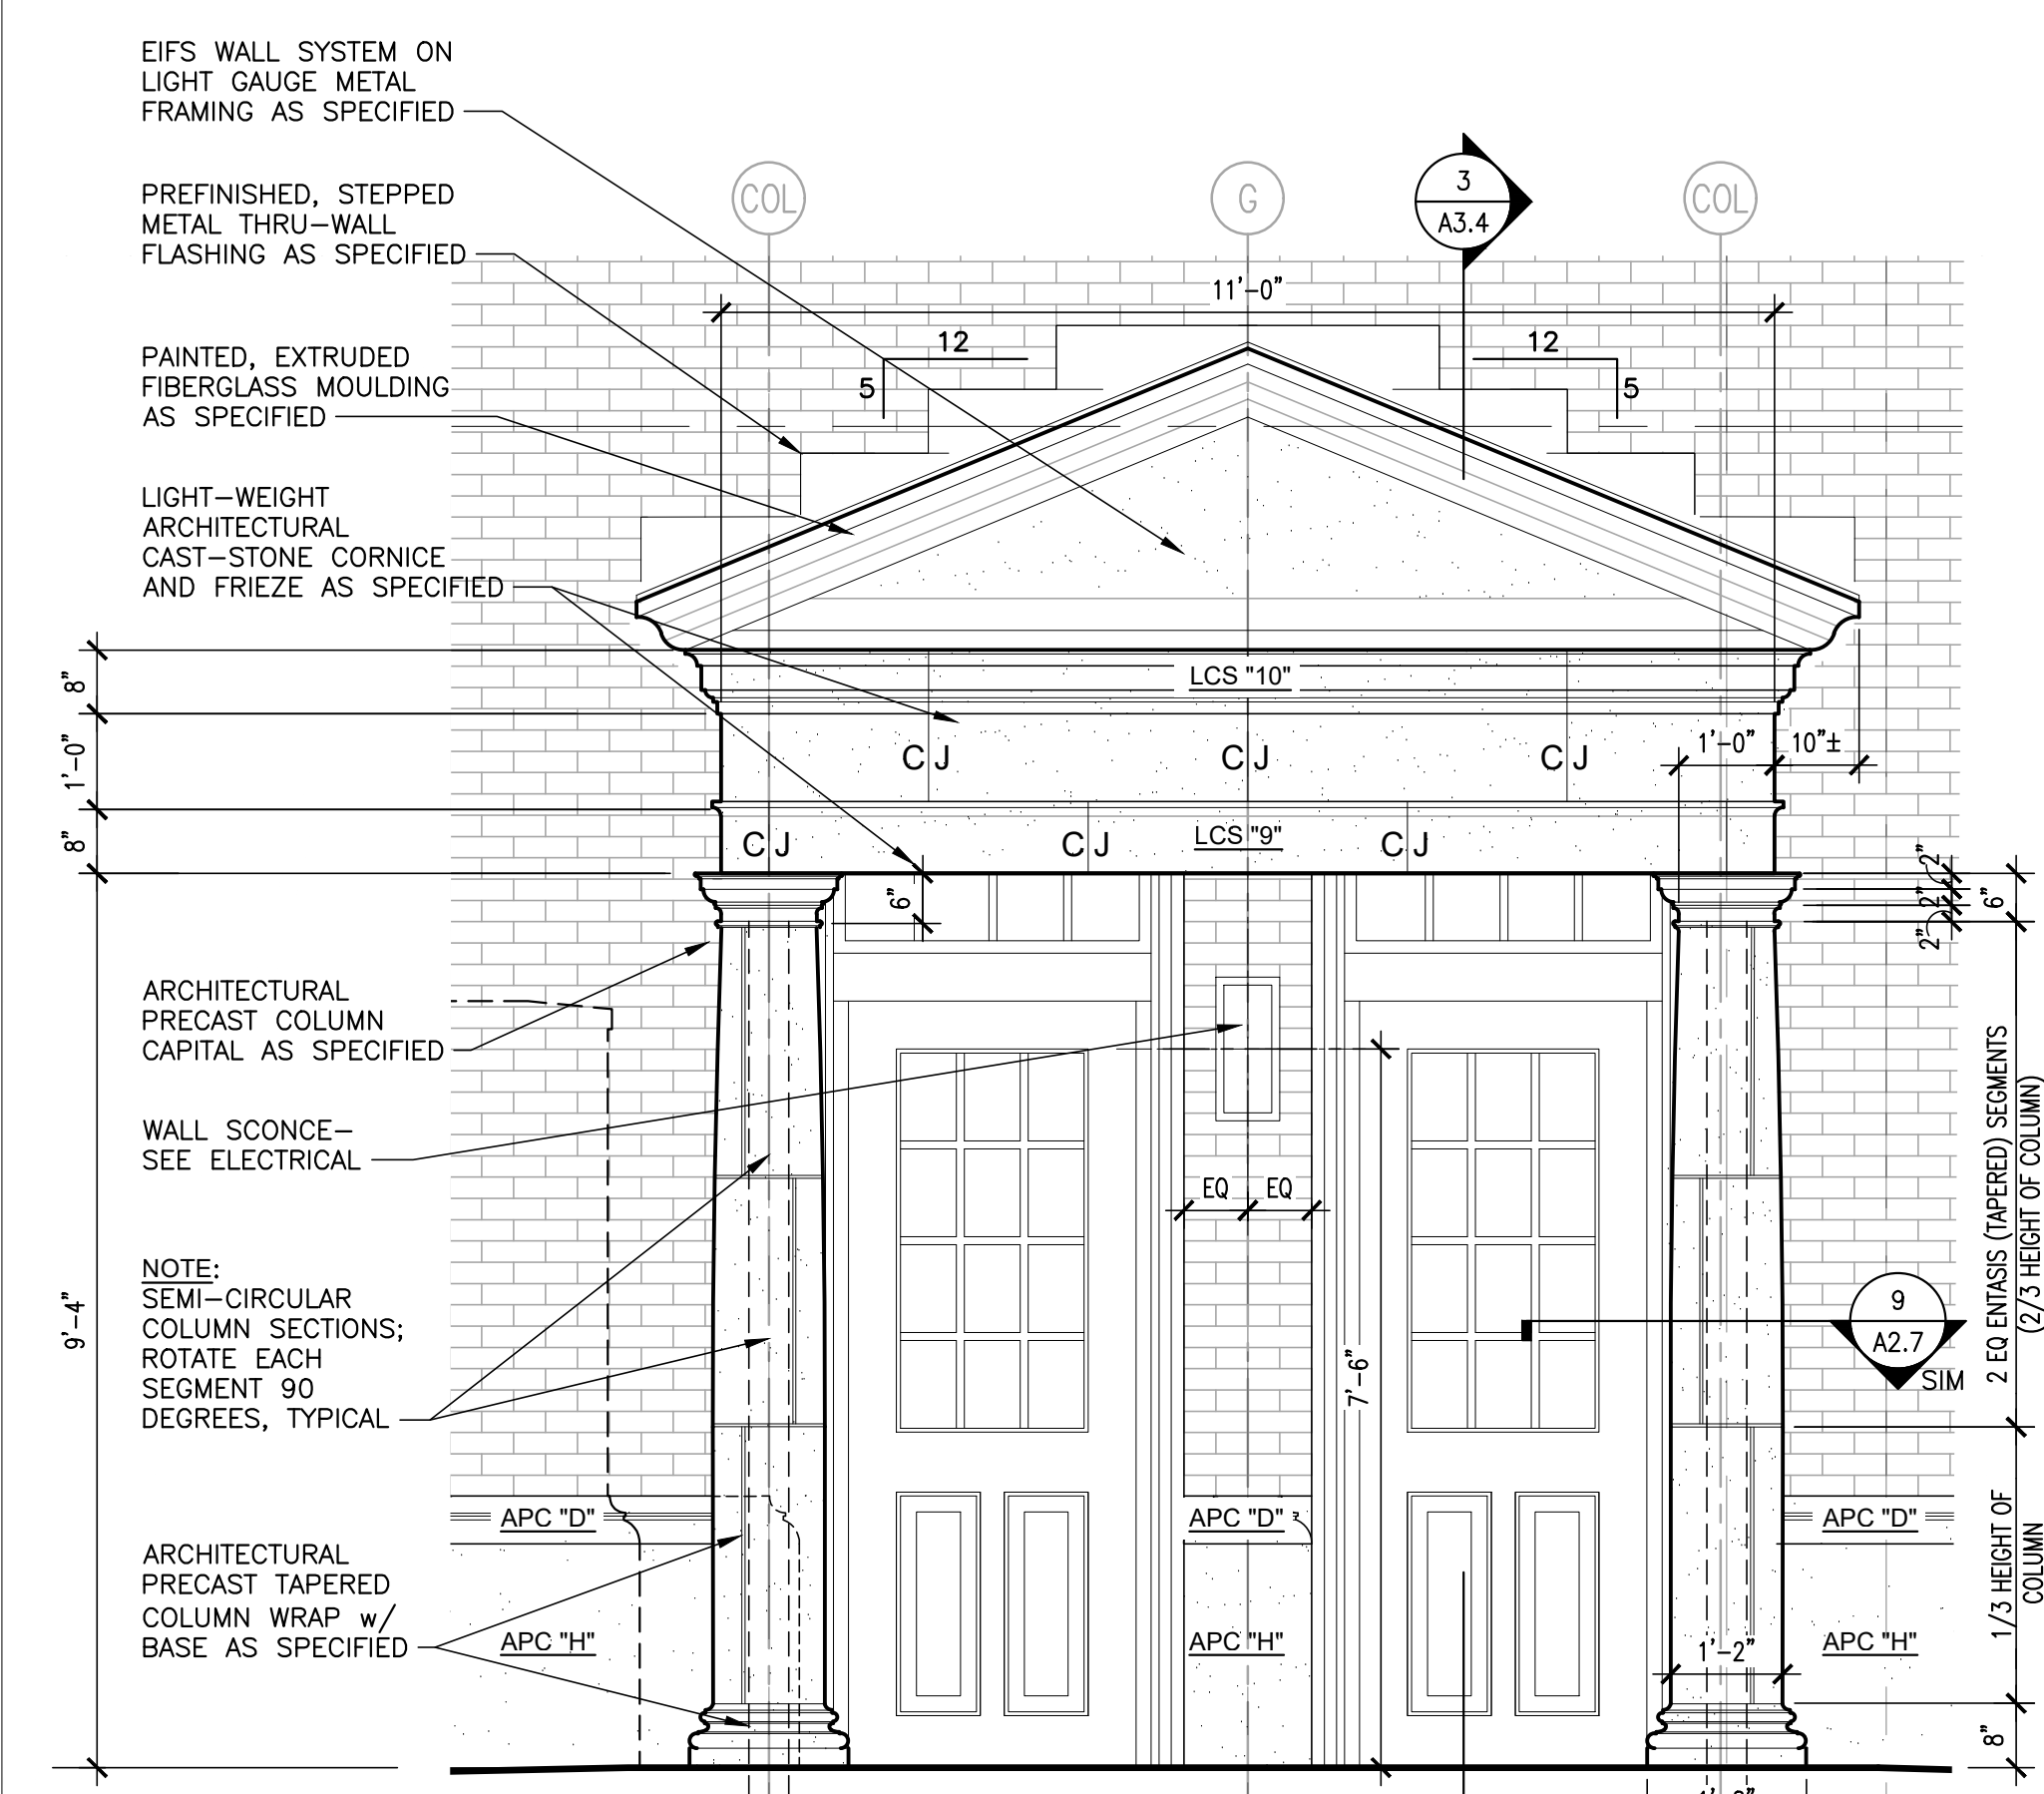


C EAST/WEST PORTICO ELEVATION
1/2" = 1'-0"

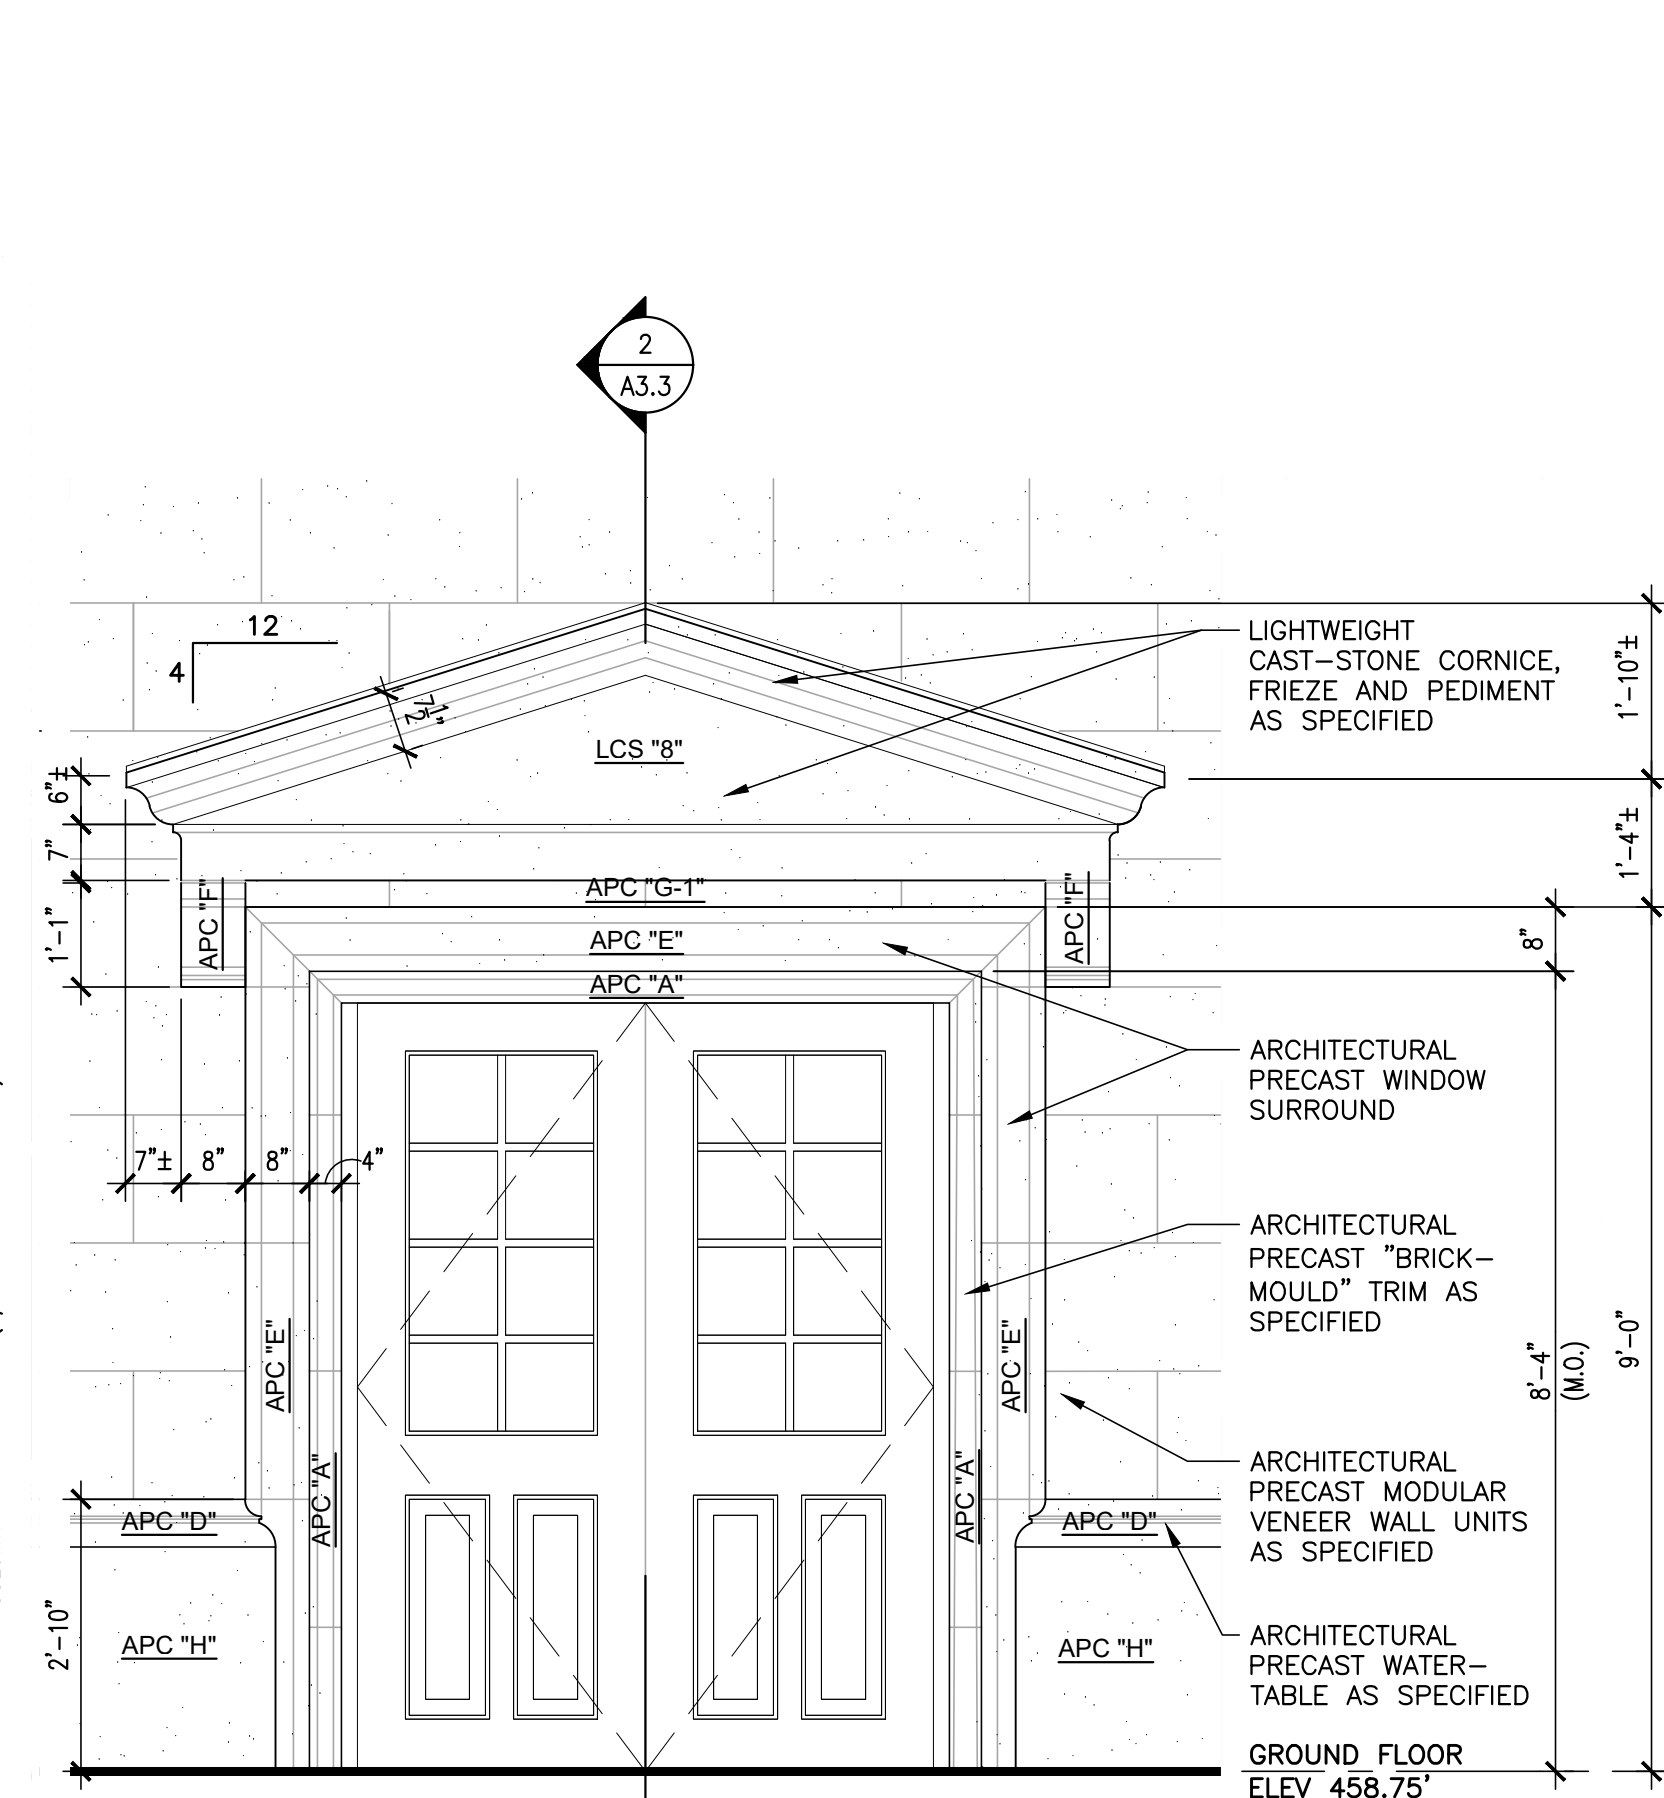


D ENLARGED ENTRY DOOR ELEVATION
1/2" = 1'-0"

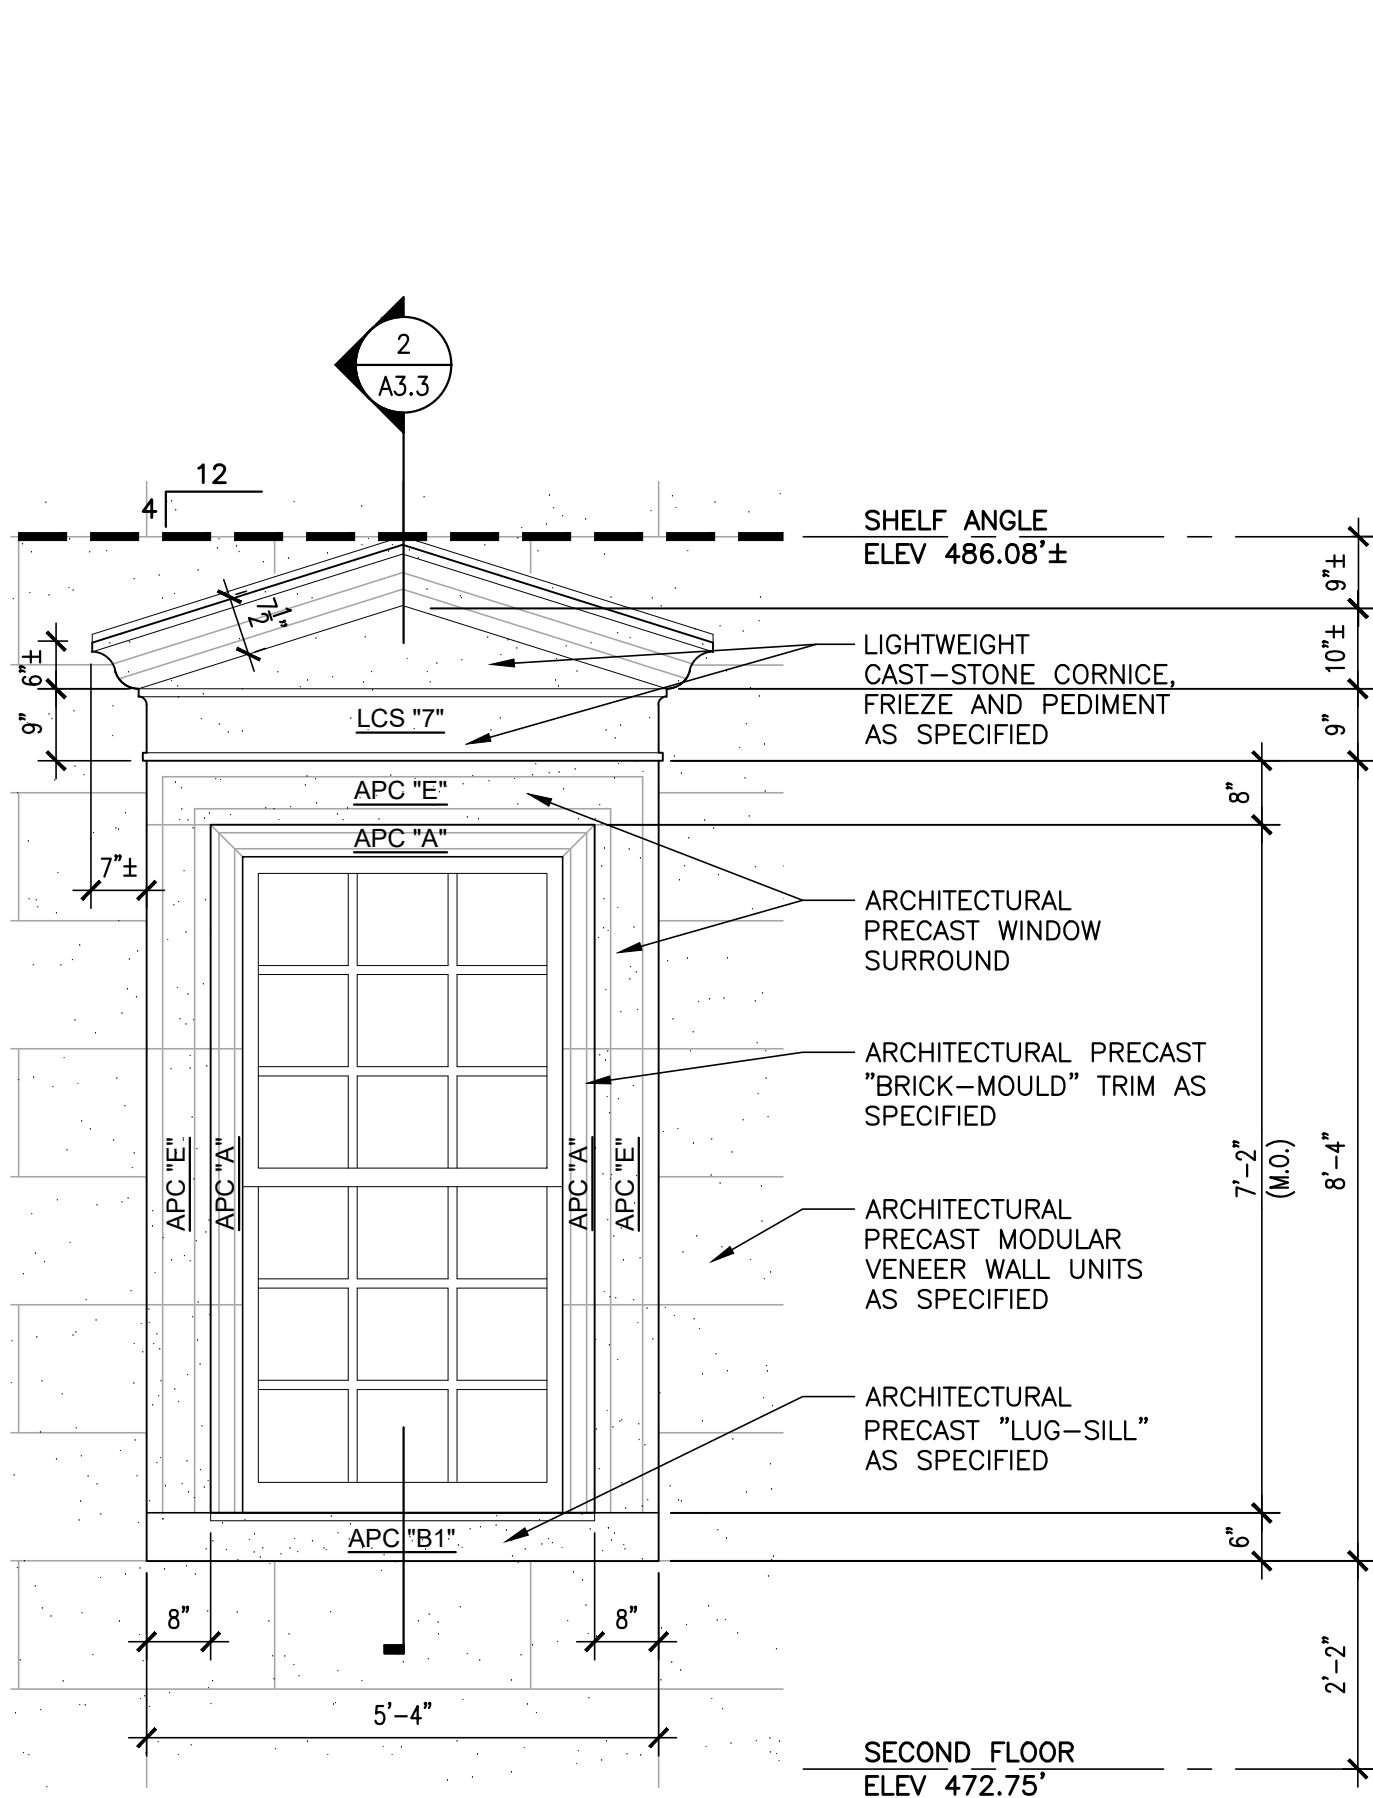

E ENLARGED WINDOW ELEVATION
1/2" = 1'-0"

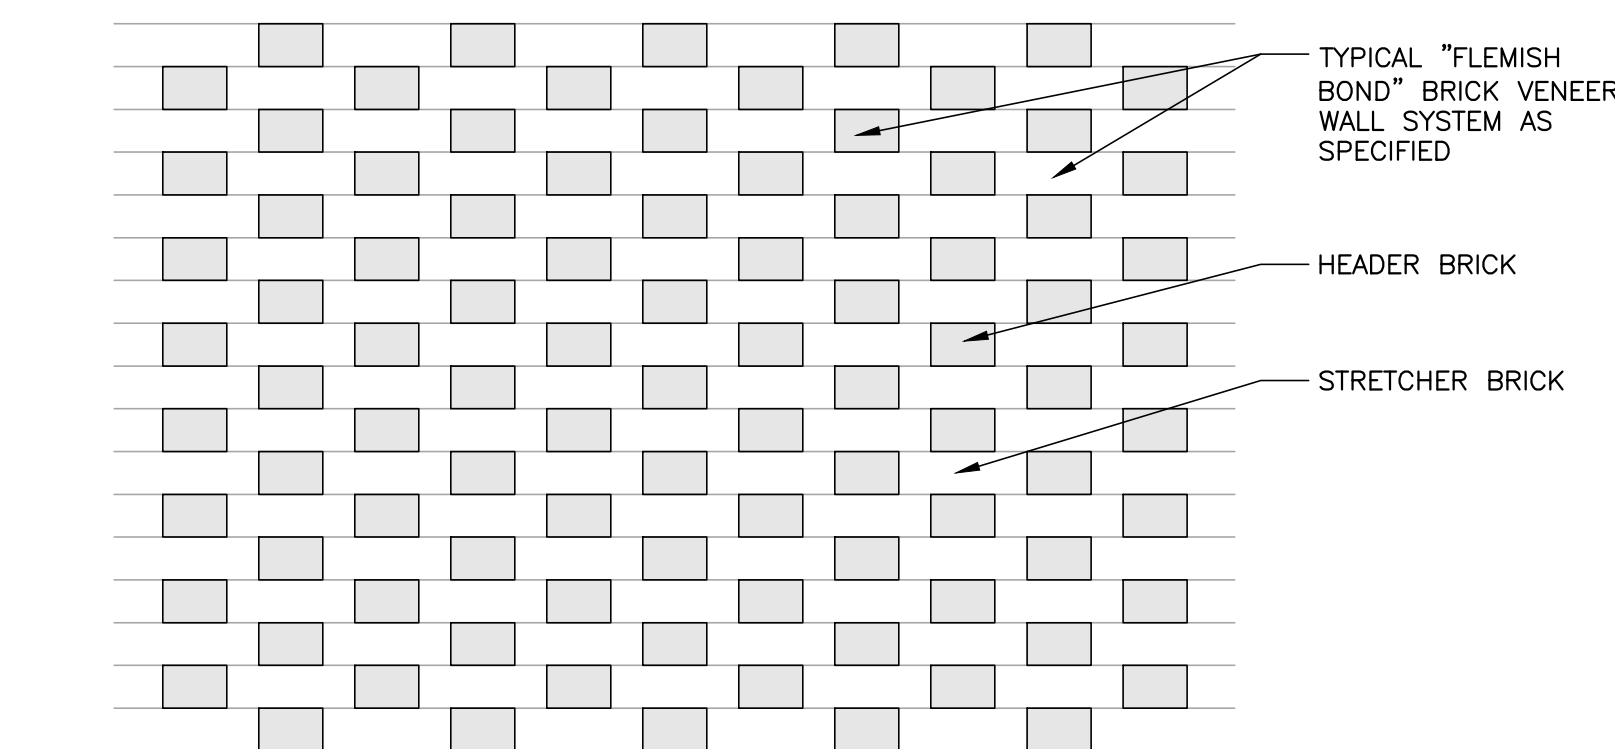

F ENLARGED BRICK DETAIL
1" = 1'-0"

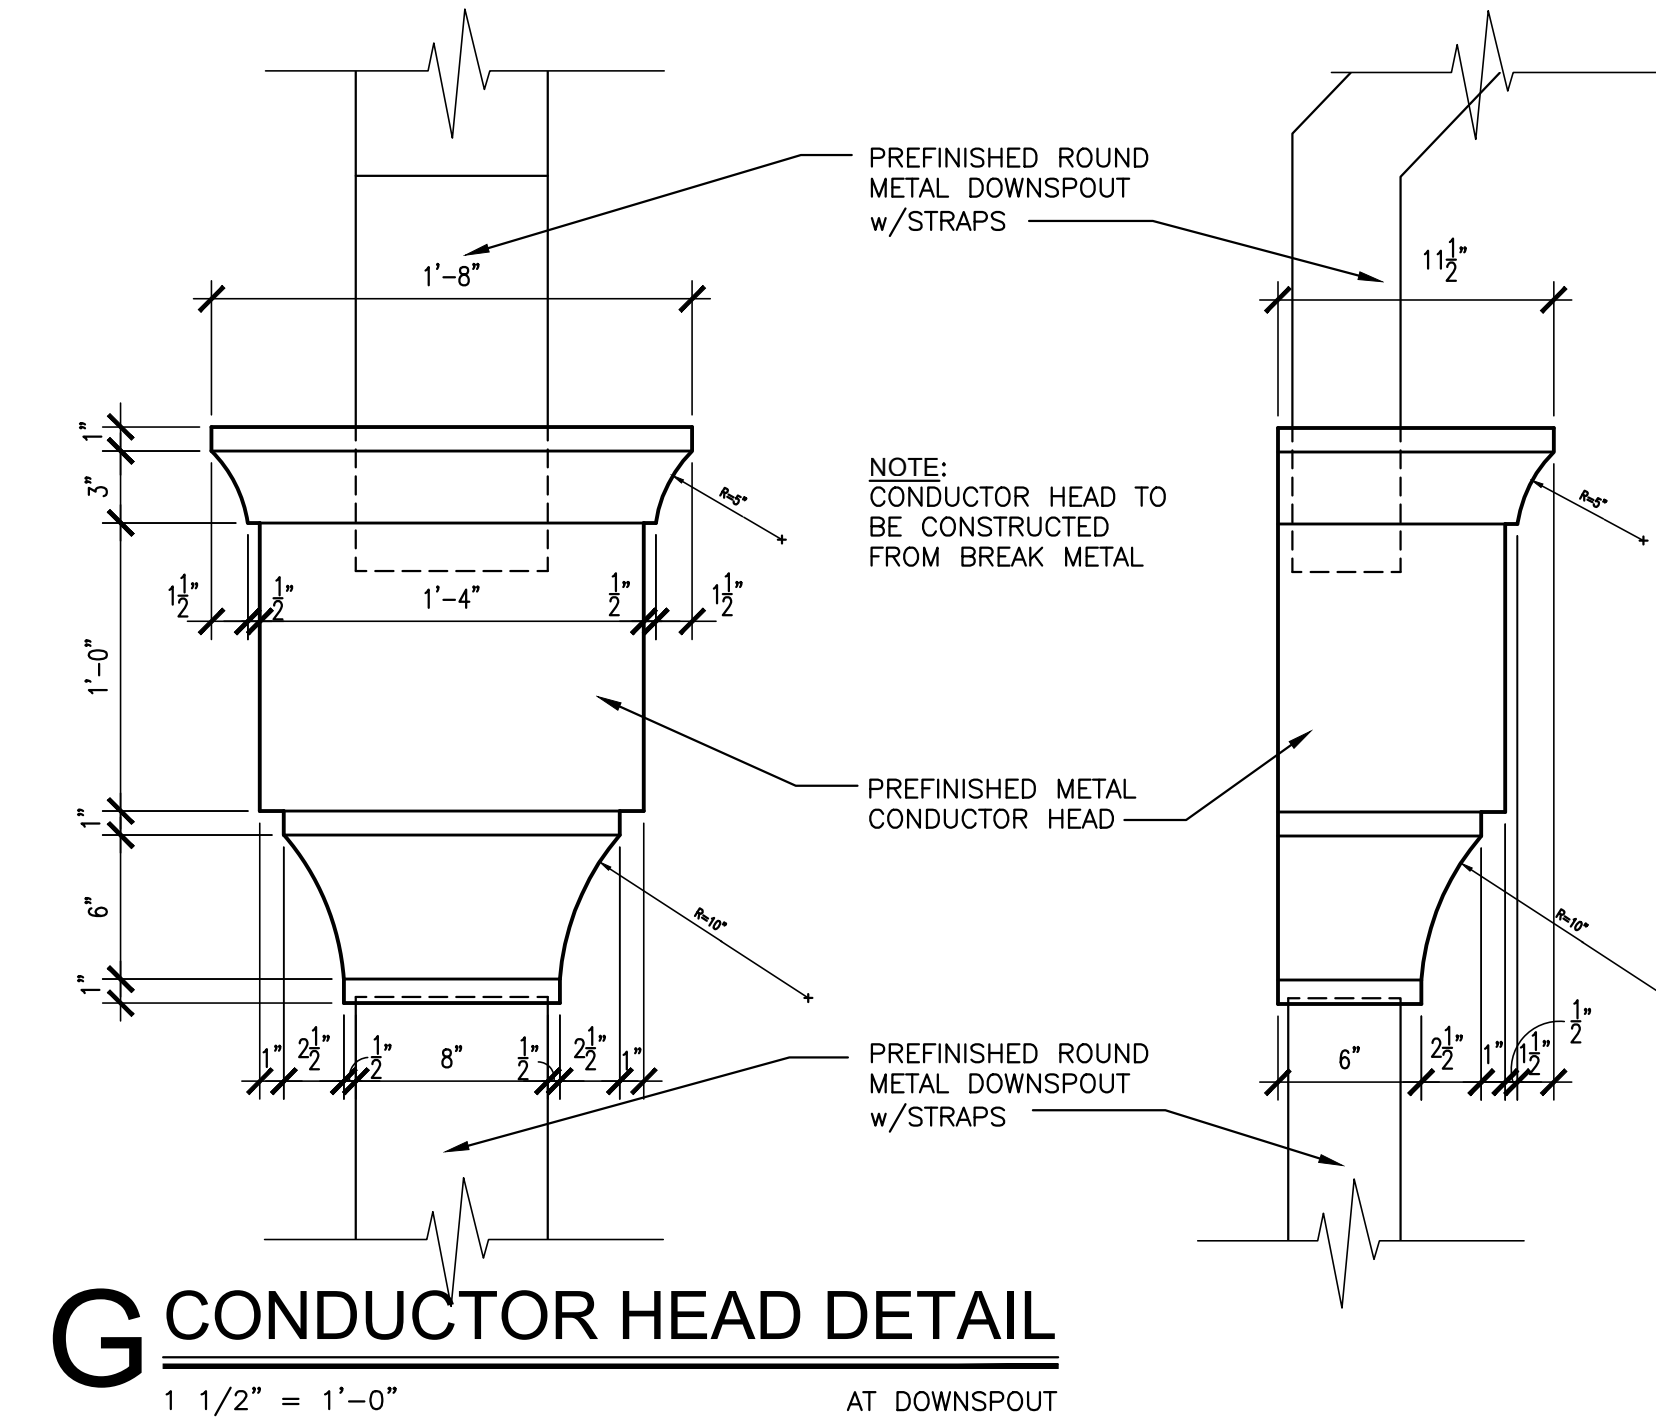

G CONDUCTOR HEAD DETAIL
1 1/2" = 1'-0"

